

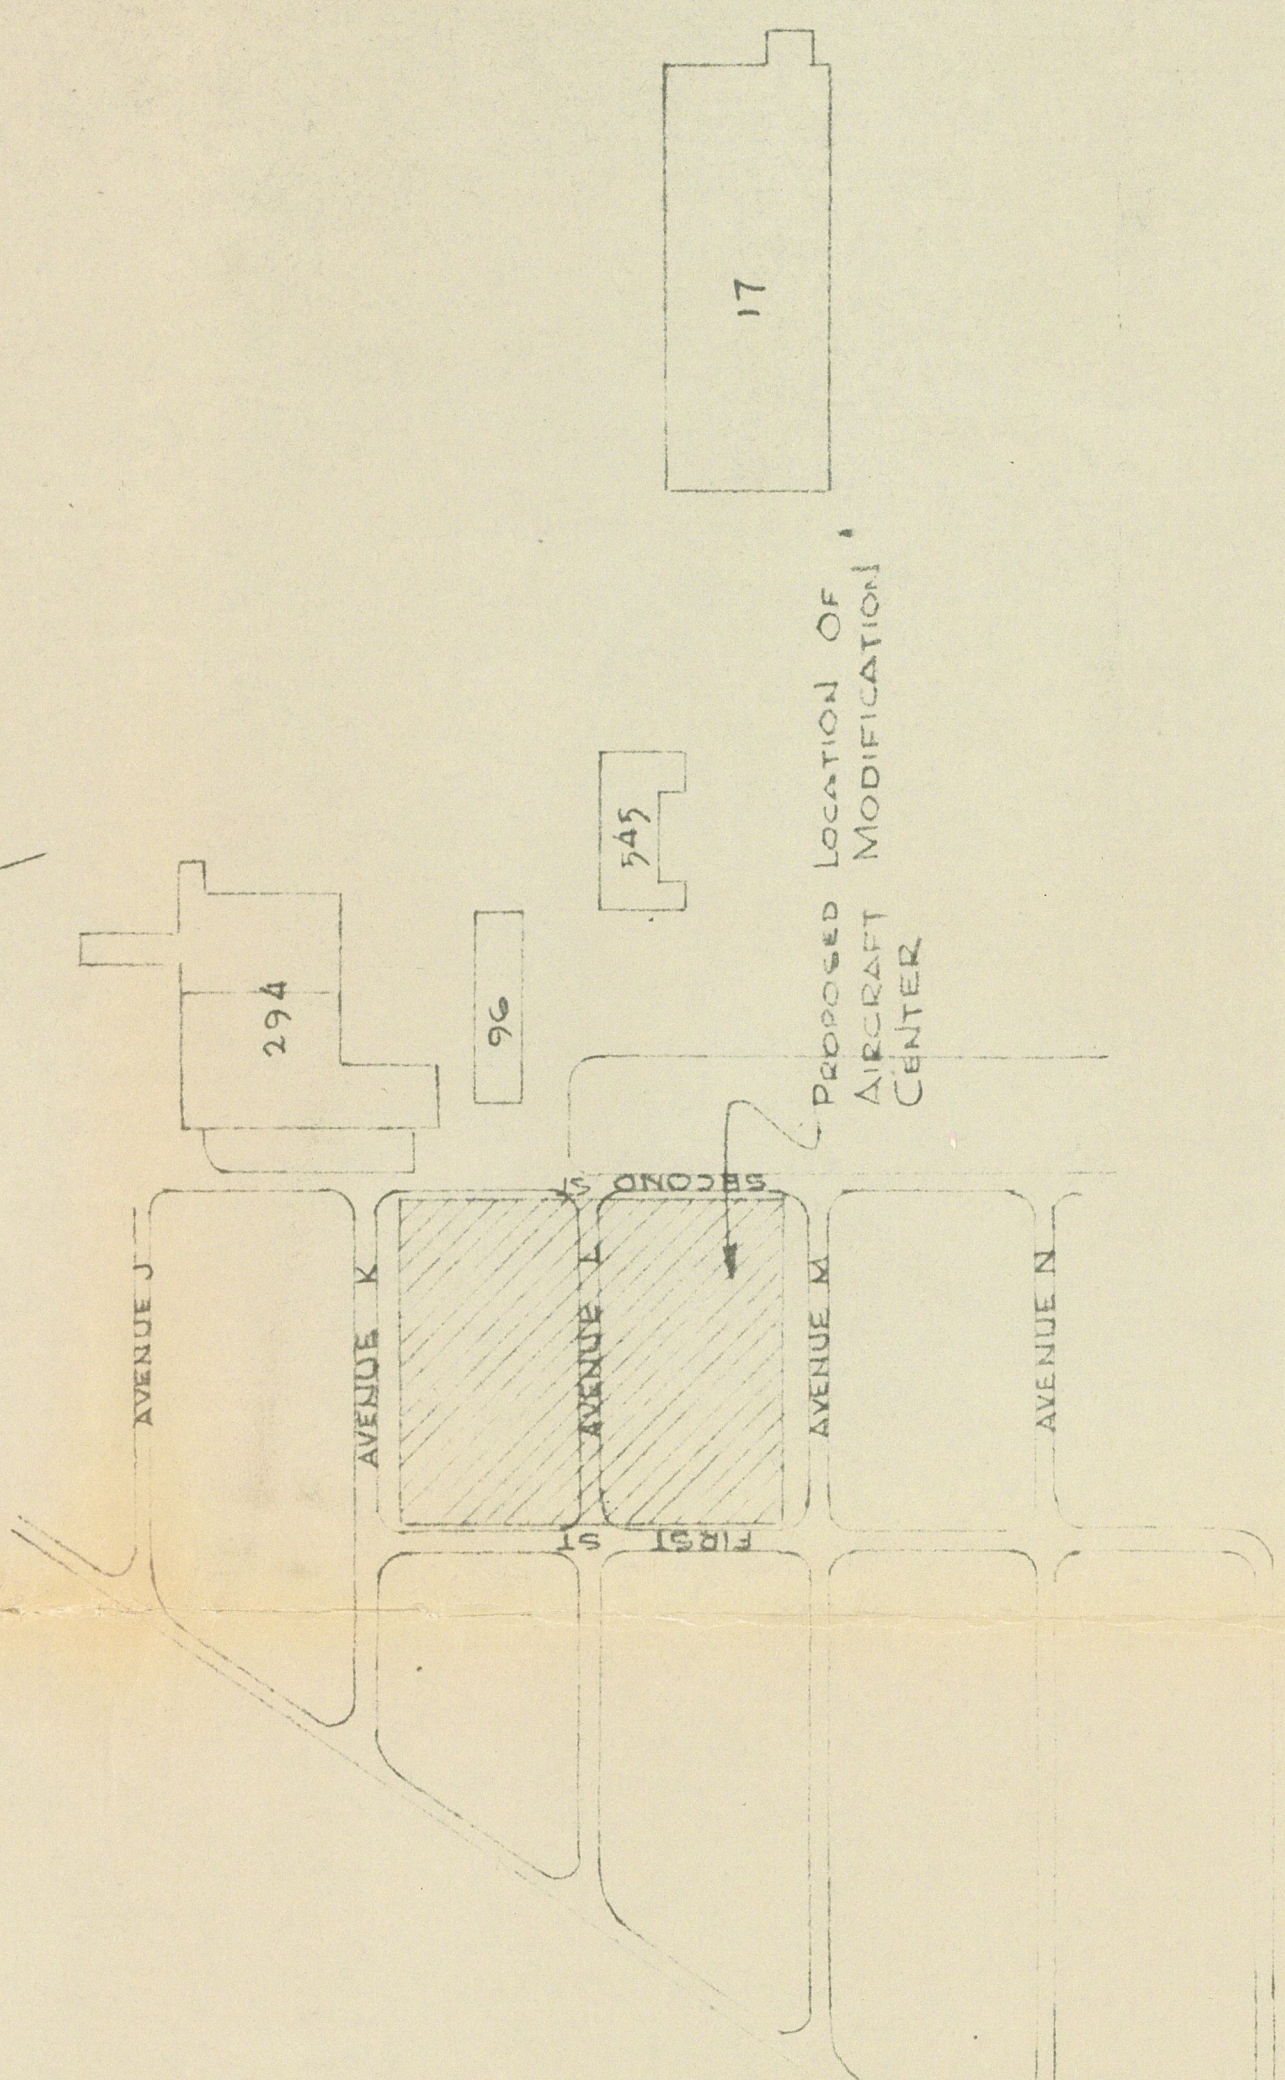


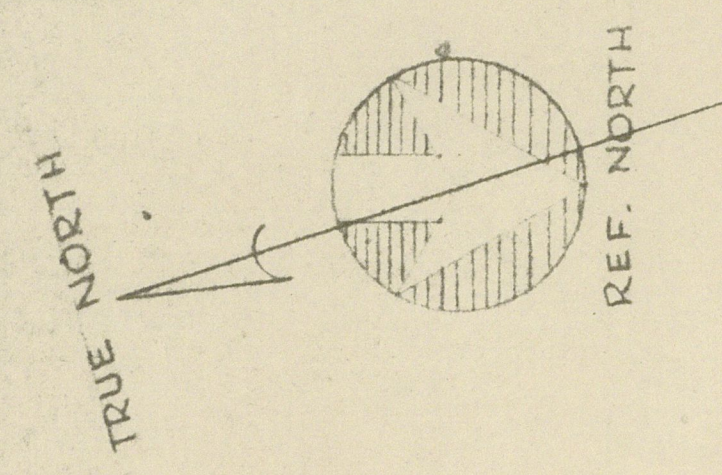

AREA PLAN
SCALE - 1" = 400'

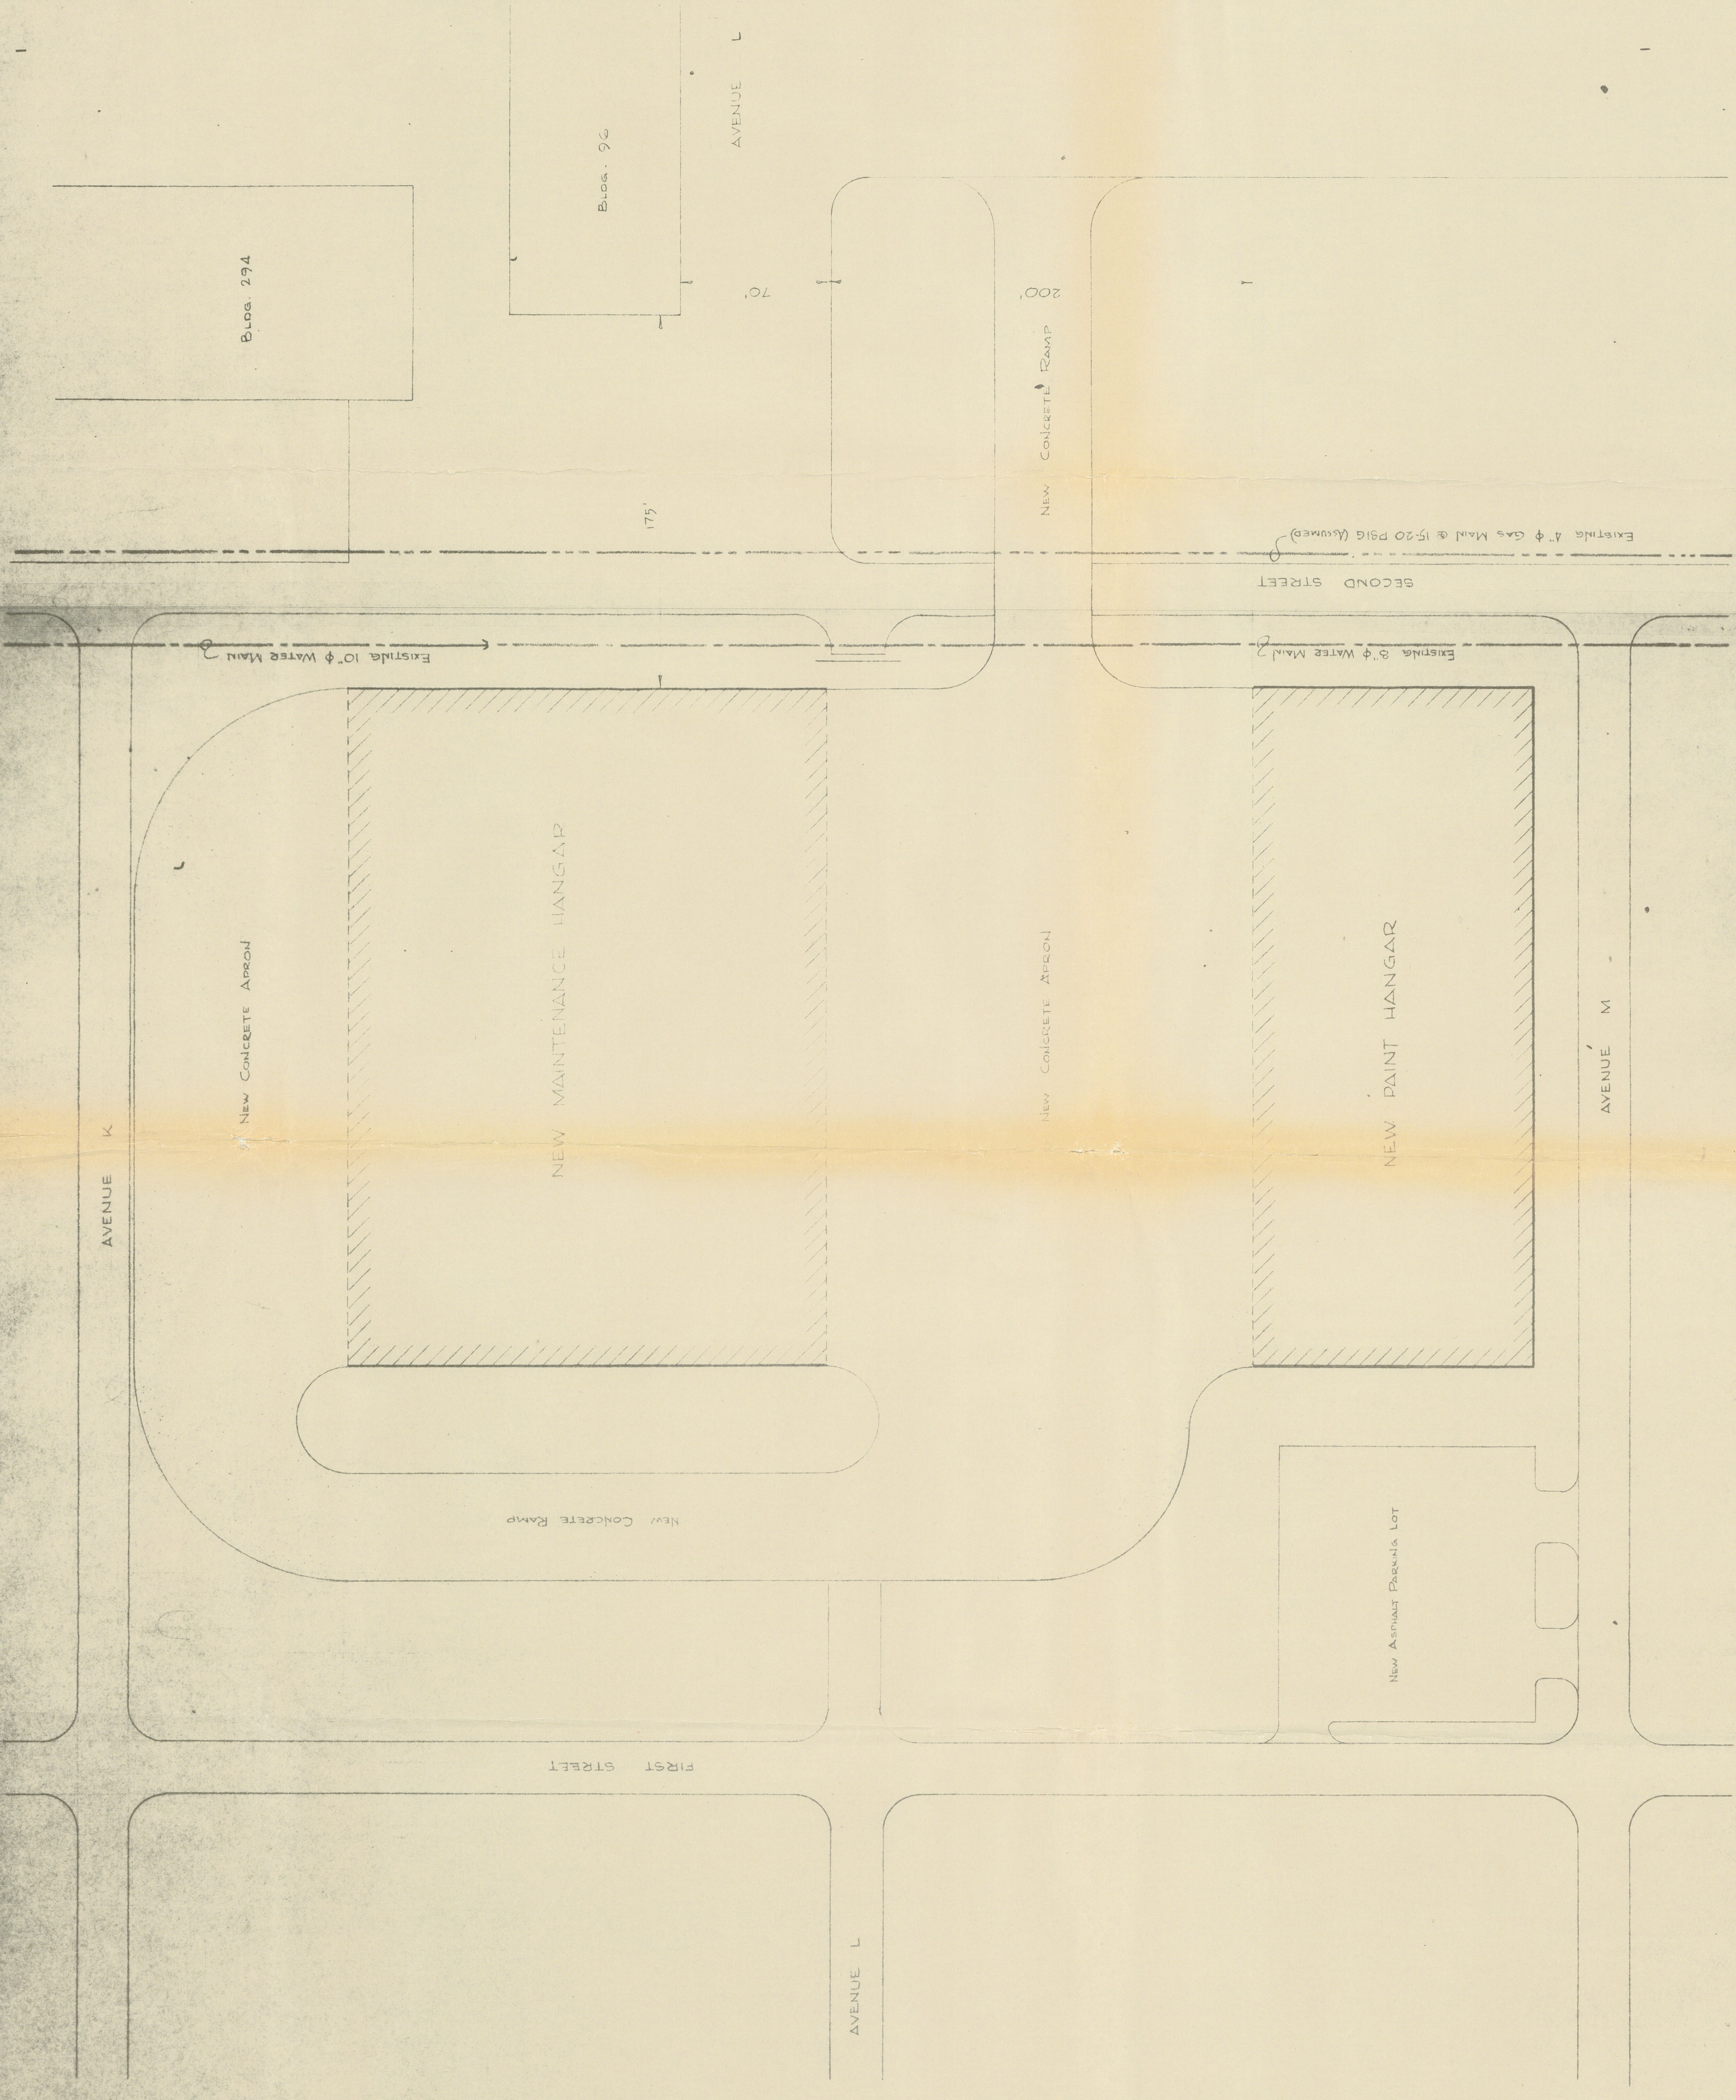

SITE PLAN
SCALE 1" = 40'

JAN 21 1971

AIRCRAFT MAINTENANCE CENTER FOR LEAR SIEGLER, INC.
MOBILE, ALABAMA

Master

THE AUSTIN COMPANY
DESIGNERS AND BUILDERS

71-8003-D-1 20 JAN 71 A.B.C.
NUMBER DATE ISSUED DRAWN BY