
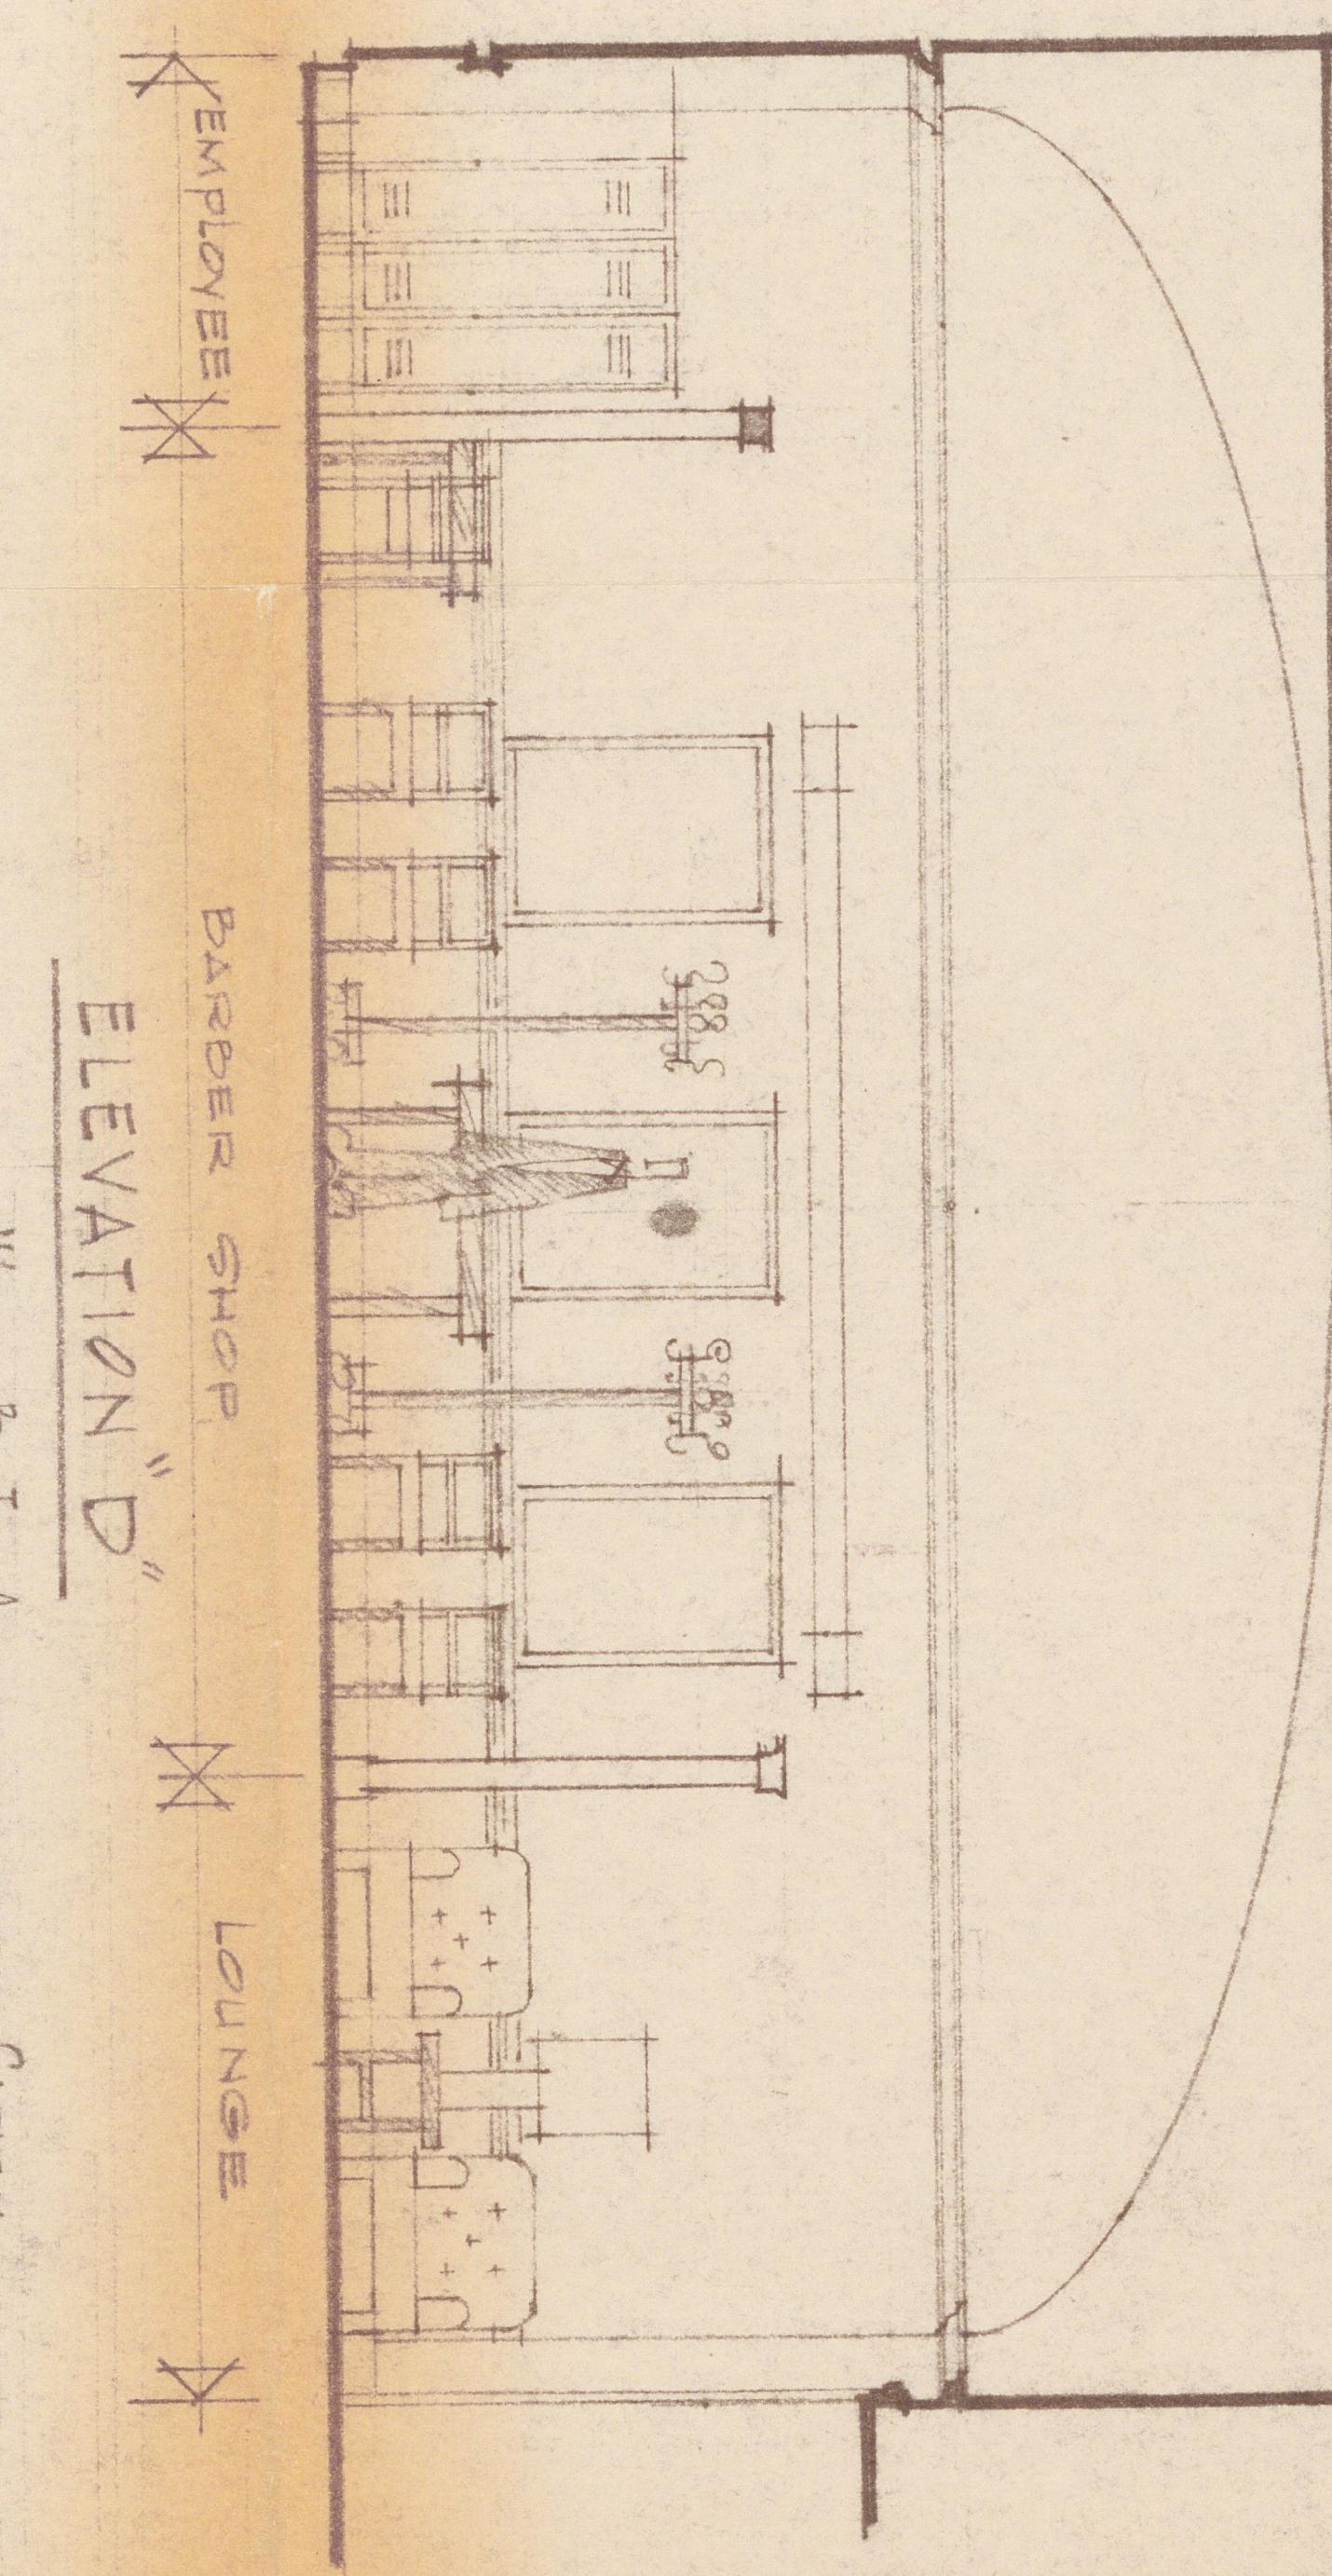
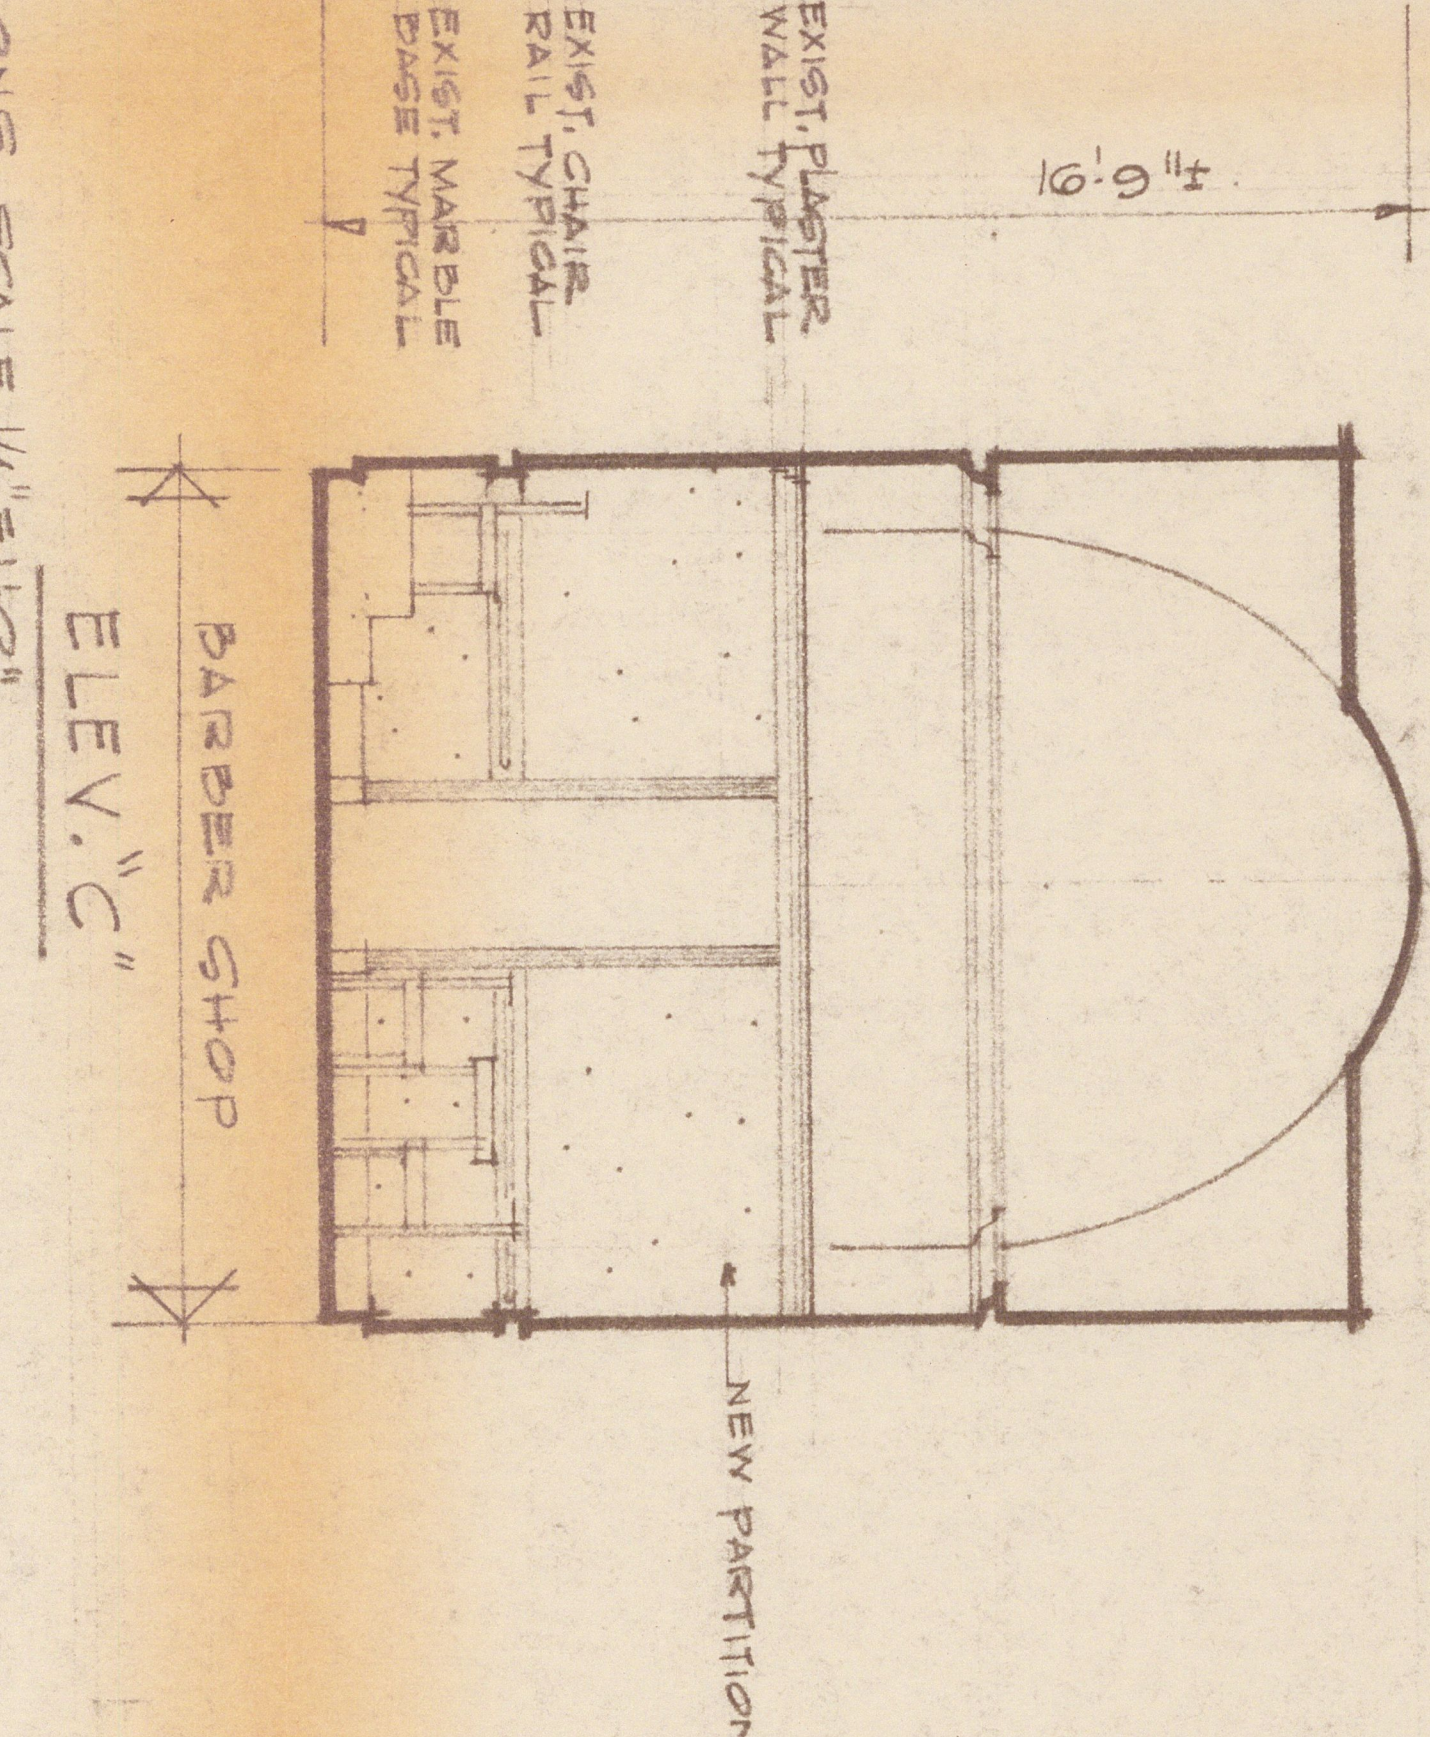
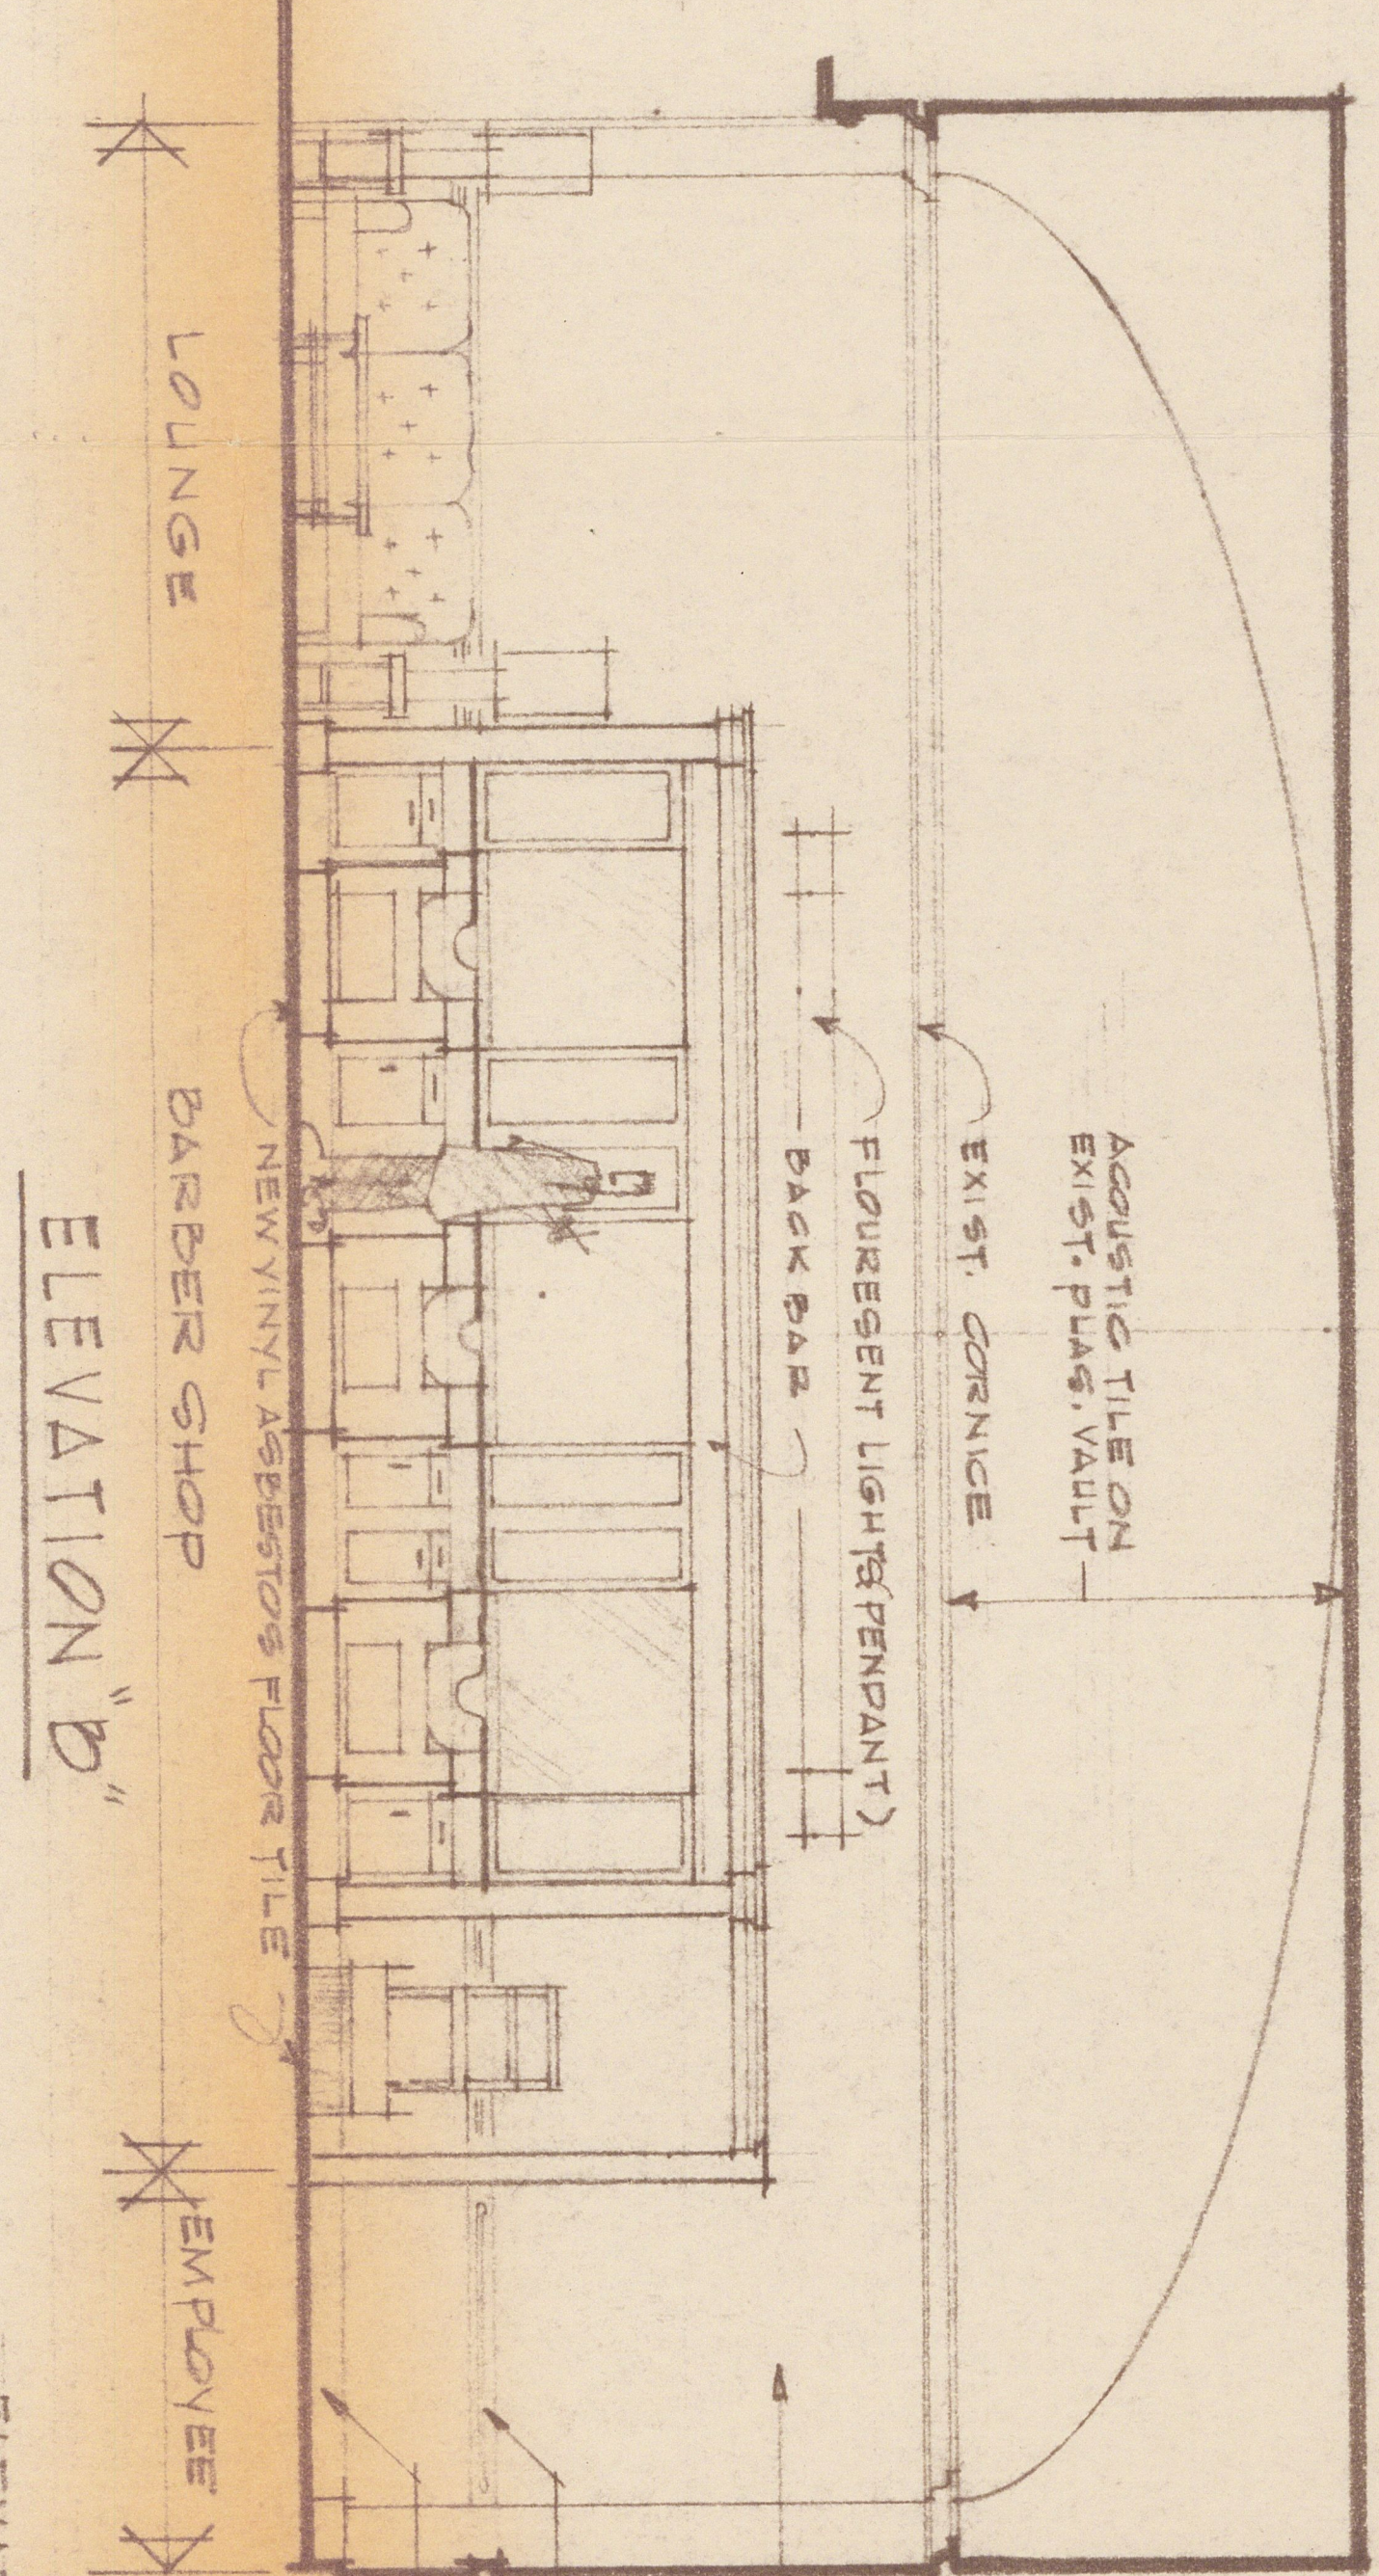


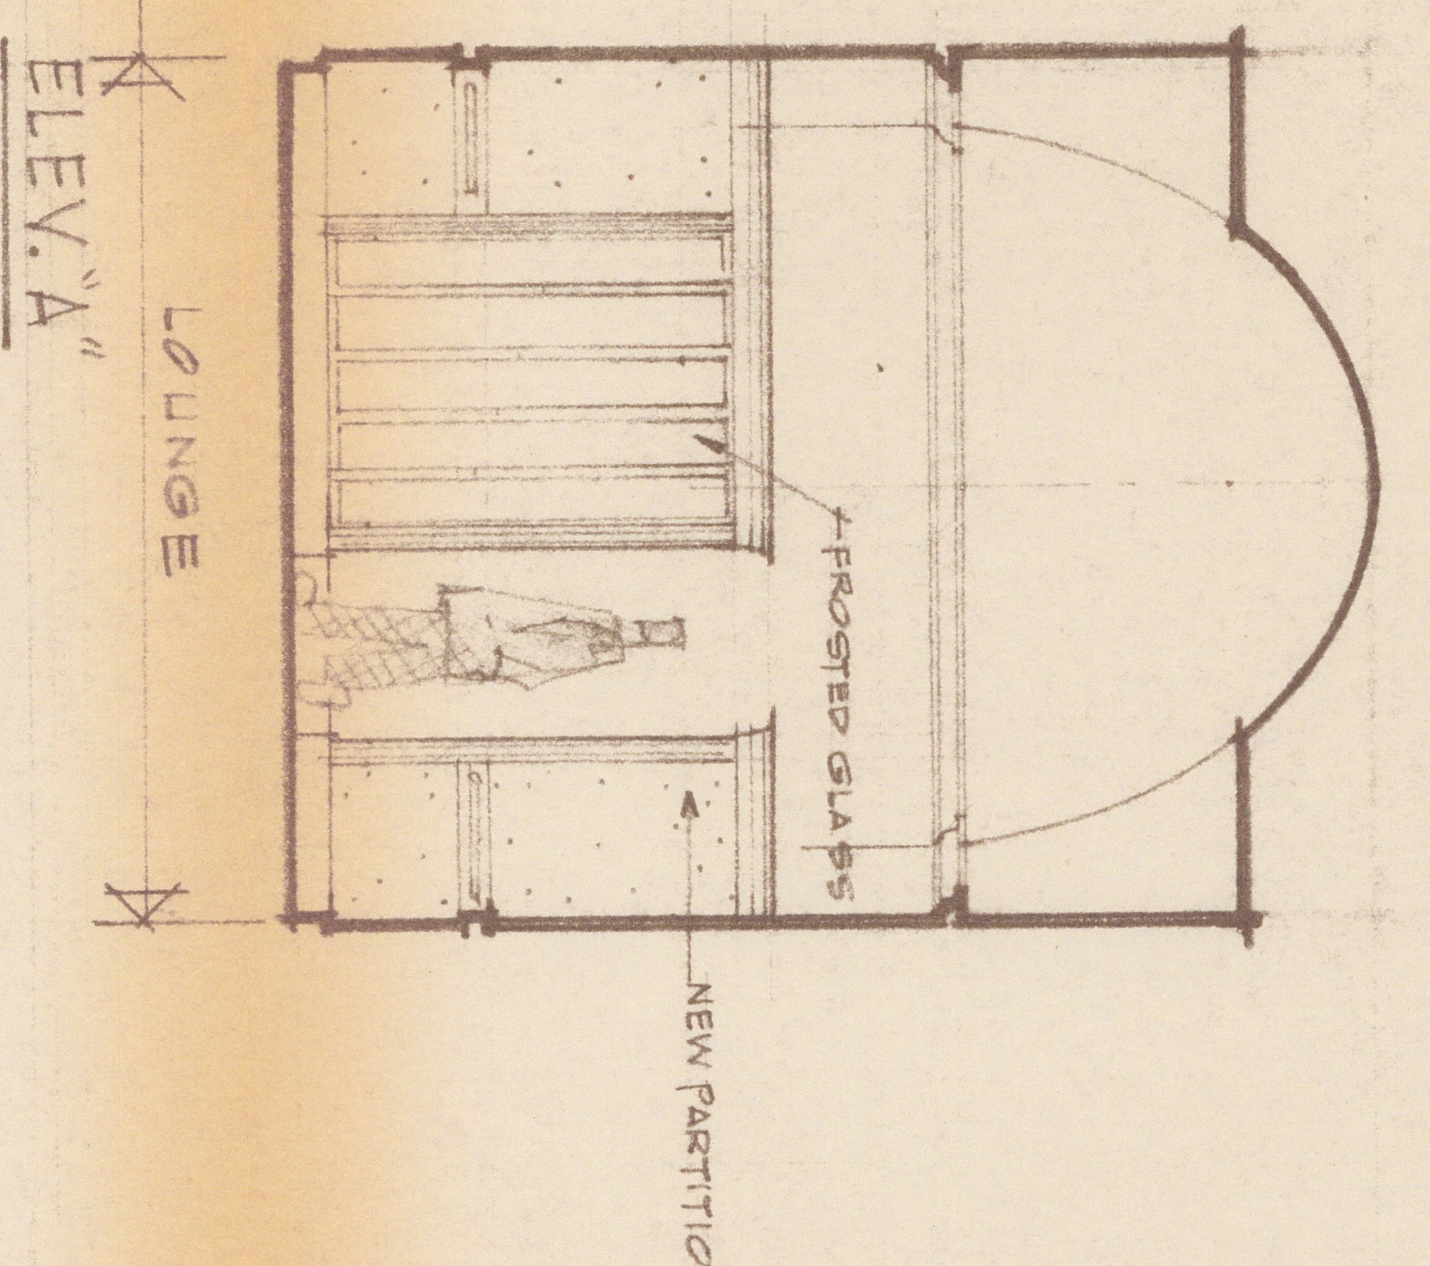

ELEV. A"

ELEVATION "B"


ELEV. C"

ELEVATION "D"

Work by the Architect of the Capitol

1. PROVIDE & INSTALL VINYL ASBESTOS TILE FLOORING IN ENTIRE ROOM.
2. RAISE EXISTING CHAIR RAILS & PATCH PLASTER AS REQUIRED BY FURNITURE HEIGHT.
3. PROVIDE & INSTALL PLASTERED MASONRY PARTITIONS; 7'6" HIGH WITH WOOD BASE, CHAIR RAIL & CAP TRIM, NEW DOOR & FRAME INDICATED THUS:
4. REMOVE EXIST. WALL SCENES AND PENDANT LIGHT FIXTURES. PATCH PLASTER AS REQUIRED
5. PROVIDE & INSTALL ACUSTIC TILE UPON EXISTING WAISTED PLASTER CEILING DOWN TO WAIST SPRING LINE
6. PAINT INTERIOR WALLS, DOORS & TRIM.
7. PROVIDE & INSTALL ALL WATER, WASTE & VENT PIPING. MAKE FINAL CONNECTIONS TO PLUMBING FIXTURES.
8. IN ADDITION TO WORK SHOWN PROVIDE & INSTALL ALL WIRING, SWITCHES & CONVENIENCE OUTLETS READ.
9. PROVIDE DESIGN FOR BACKBAR TO BE FURNISHED BY OTHERS
10. INSTALL BACKBAR TO BE FURNISHED BY OTHERS.

10'-0 1/2 ±
18'8" CENTER IN ROOM
39'5" ±
ELEVATIONS SCALE 1/4" = 1'-0"

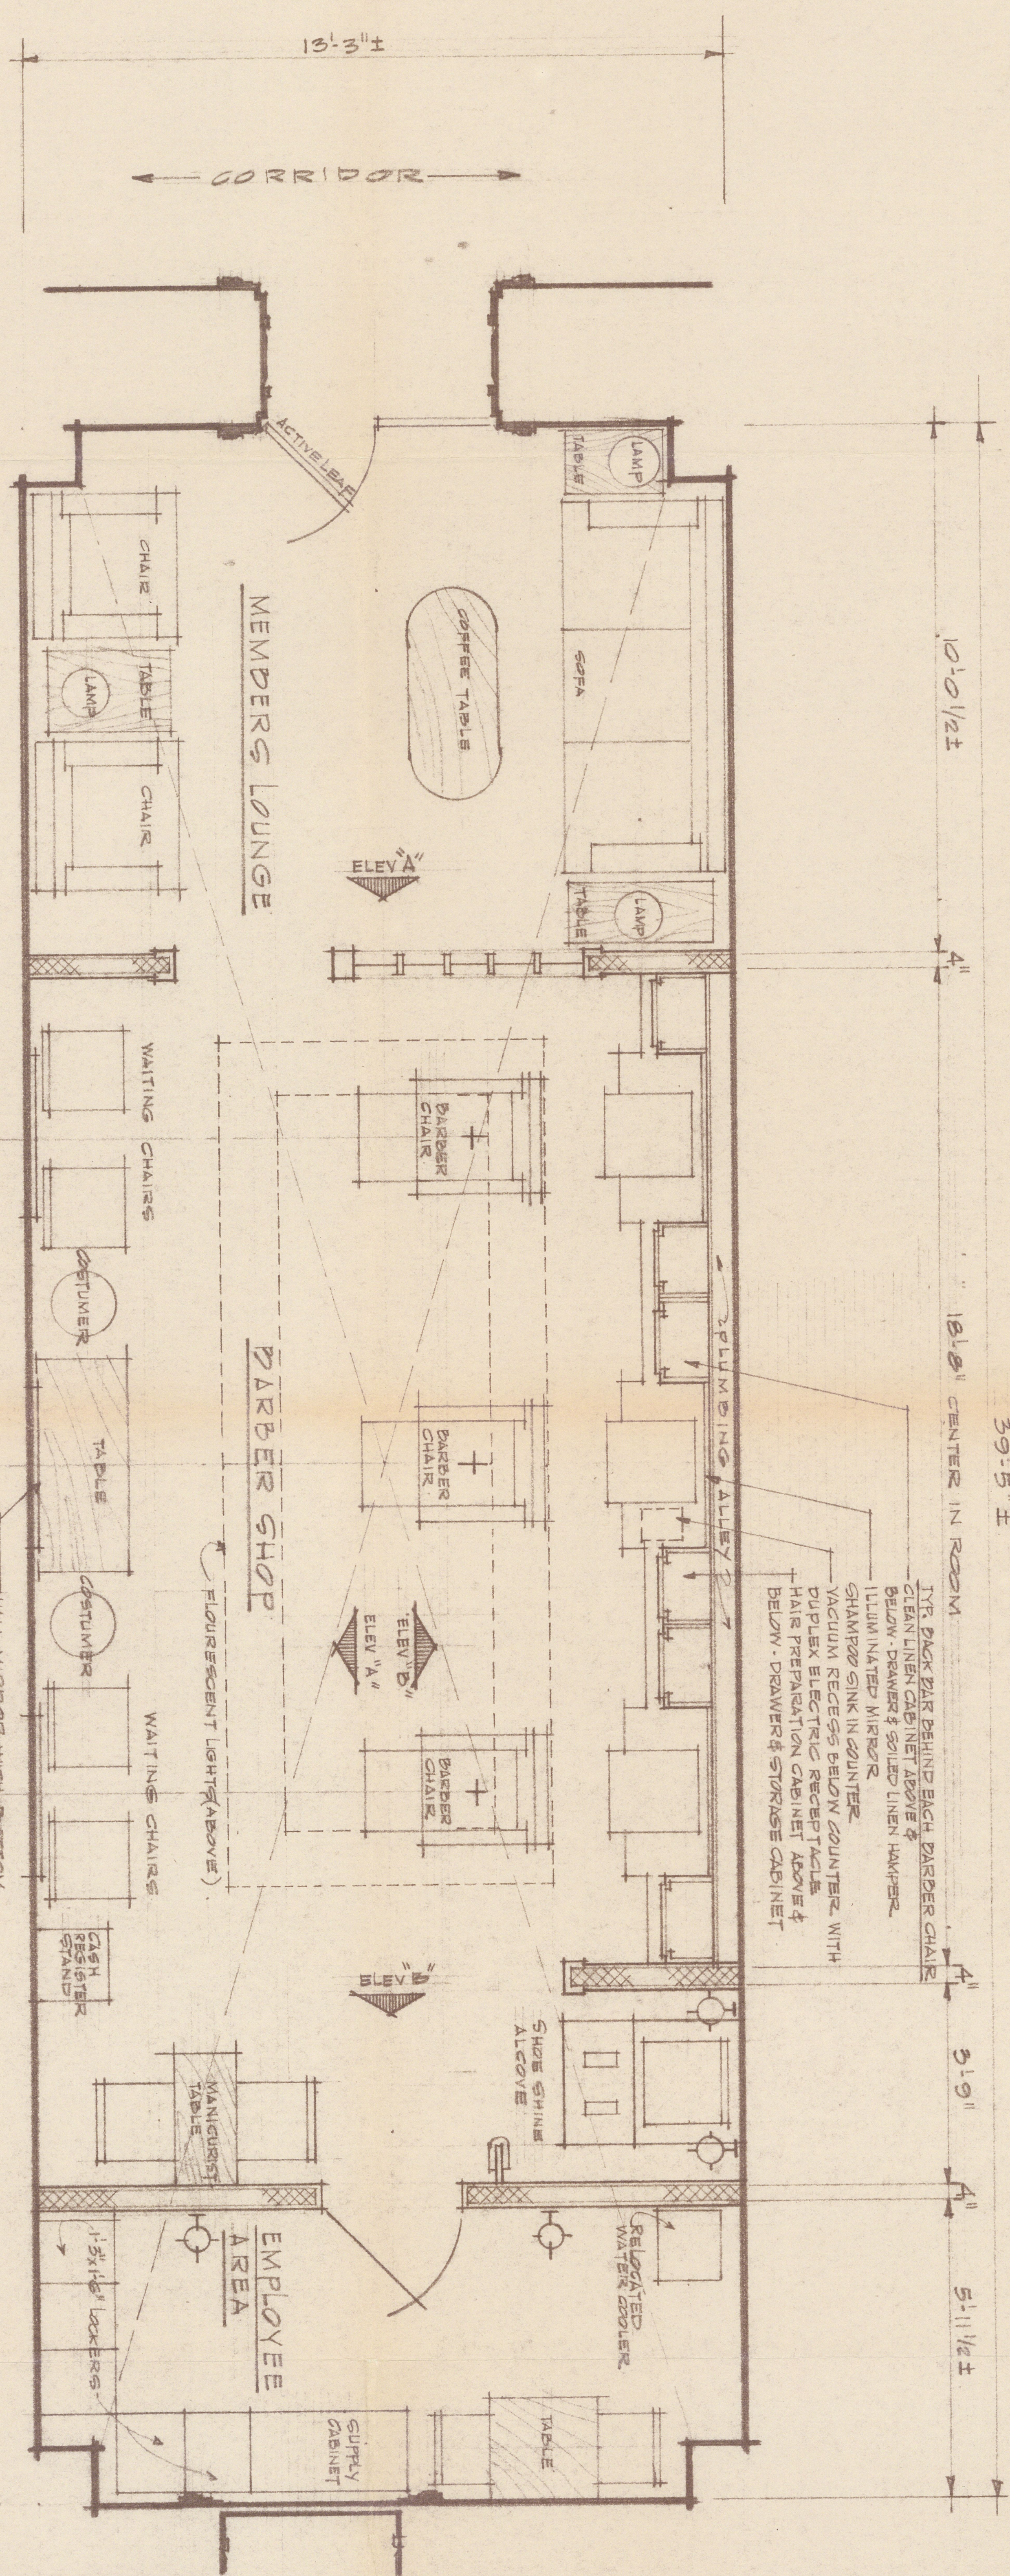

PLAN OF ROOM H-139 SCALE 1/2" = 1'-0"

ITEMS TO BE FURNISHED BY OTHERS:
CHAIRS
BARBER CHAIRS
LAMP
MIRRORS
TABLES
LOCKERS
COFFEE TABLE
SUPPLY CABINETS
SOFA
WANDERST TABLE
BACK BAR
BACKBAR

INFORMATION TO BE PROVIDED TO THE ARCHITECT FOR DESIGN PURPOSES:
FURNITURE HEIGHT
TYPE OF BARBER CHAIR
TYPE OF SHAMPOO SINK

RECOMMENDED FOR APPROVAL	PROJECT TITLE U.S. CAPITOL ROOM H-139	ALTERNATION FOR HOUSE BARBER SHOP	DESIGN NO. C-139-2
COORDINATING ENGINEER	DRAWING TITLE HOUSE BARBER SHOP	ARCHITECT OF THE CAPITOL	DATE OCT 1
ASSISTING ARCHITECT OF THE CAPITOL	HOUSE BARBER SHOP	ARCHITECT OF THE CAPITOL	
APPROVED	HOUSE BARBER SHOP	ARCHITECT OF THE CAPITOL	
ARCHITECT OF THE CAPITOL	HOUSE BARBER SHOP	ARCHITECT OF THE CAPITOL	