




PRINTS ISSUED		
NO.	TO	DATE
1	M.E.C.	4/6/77
3	J.R.C.	
3	R.A.T.	
2	MR. MALDONADO	
1	MR. HENSHAW	4/12/77
1	MR. HYMEL	

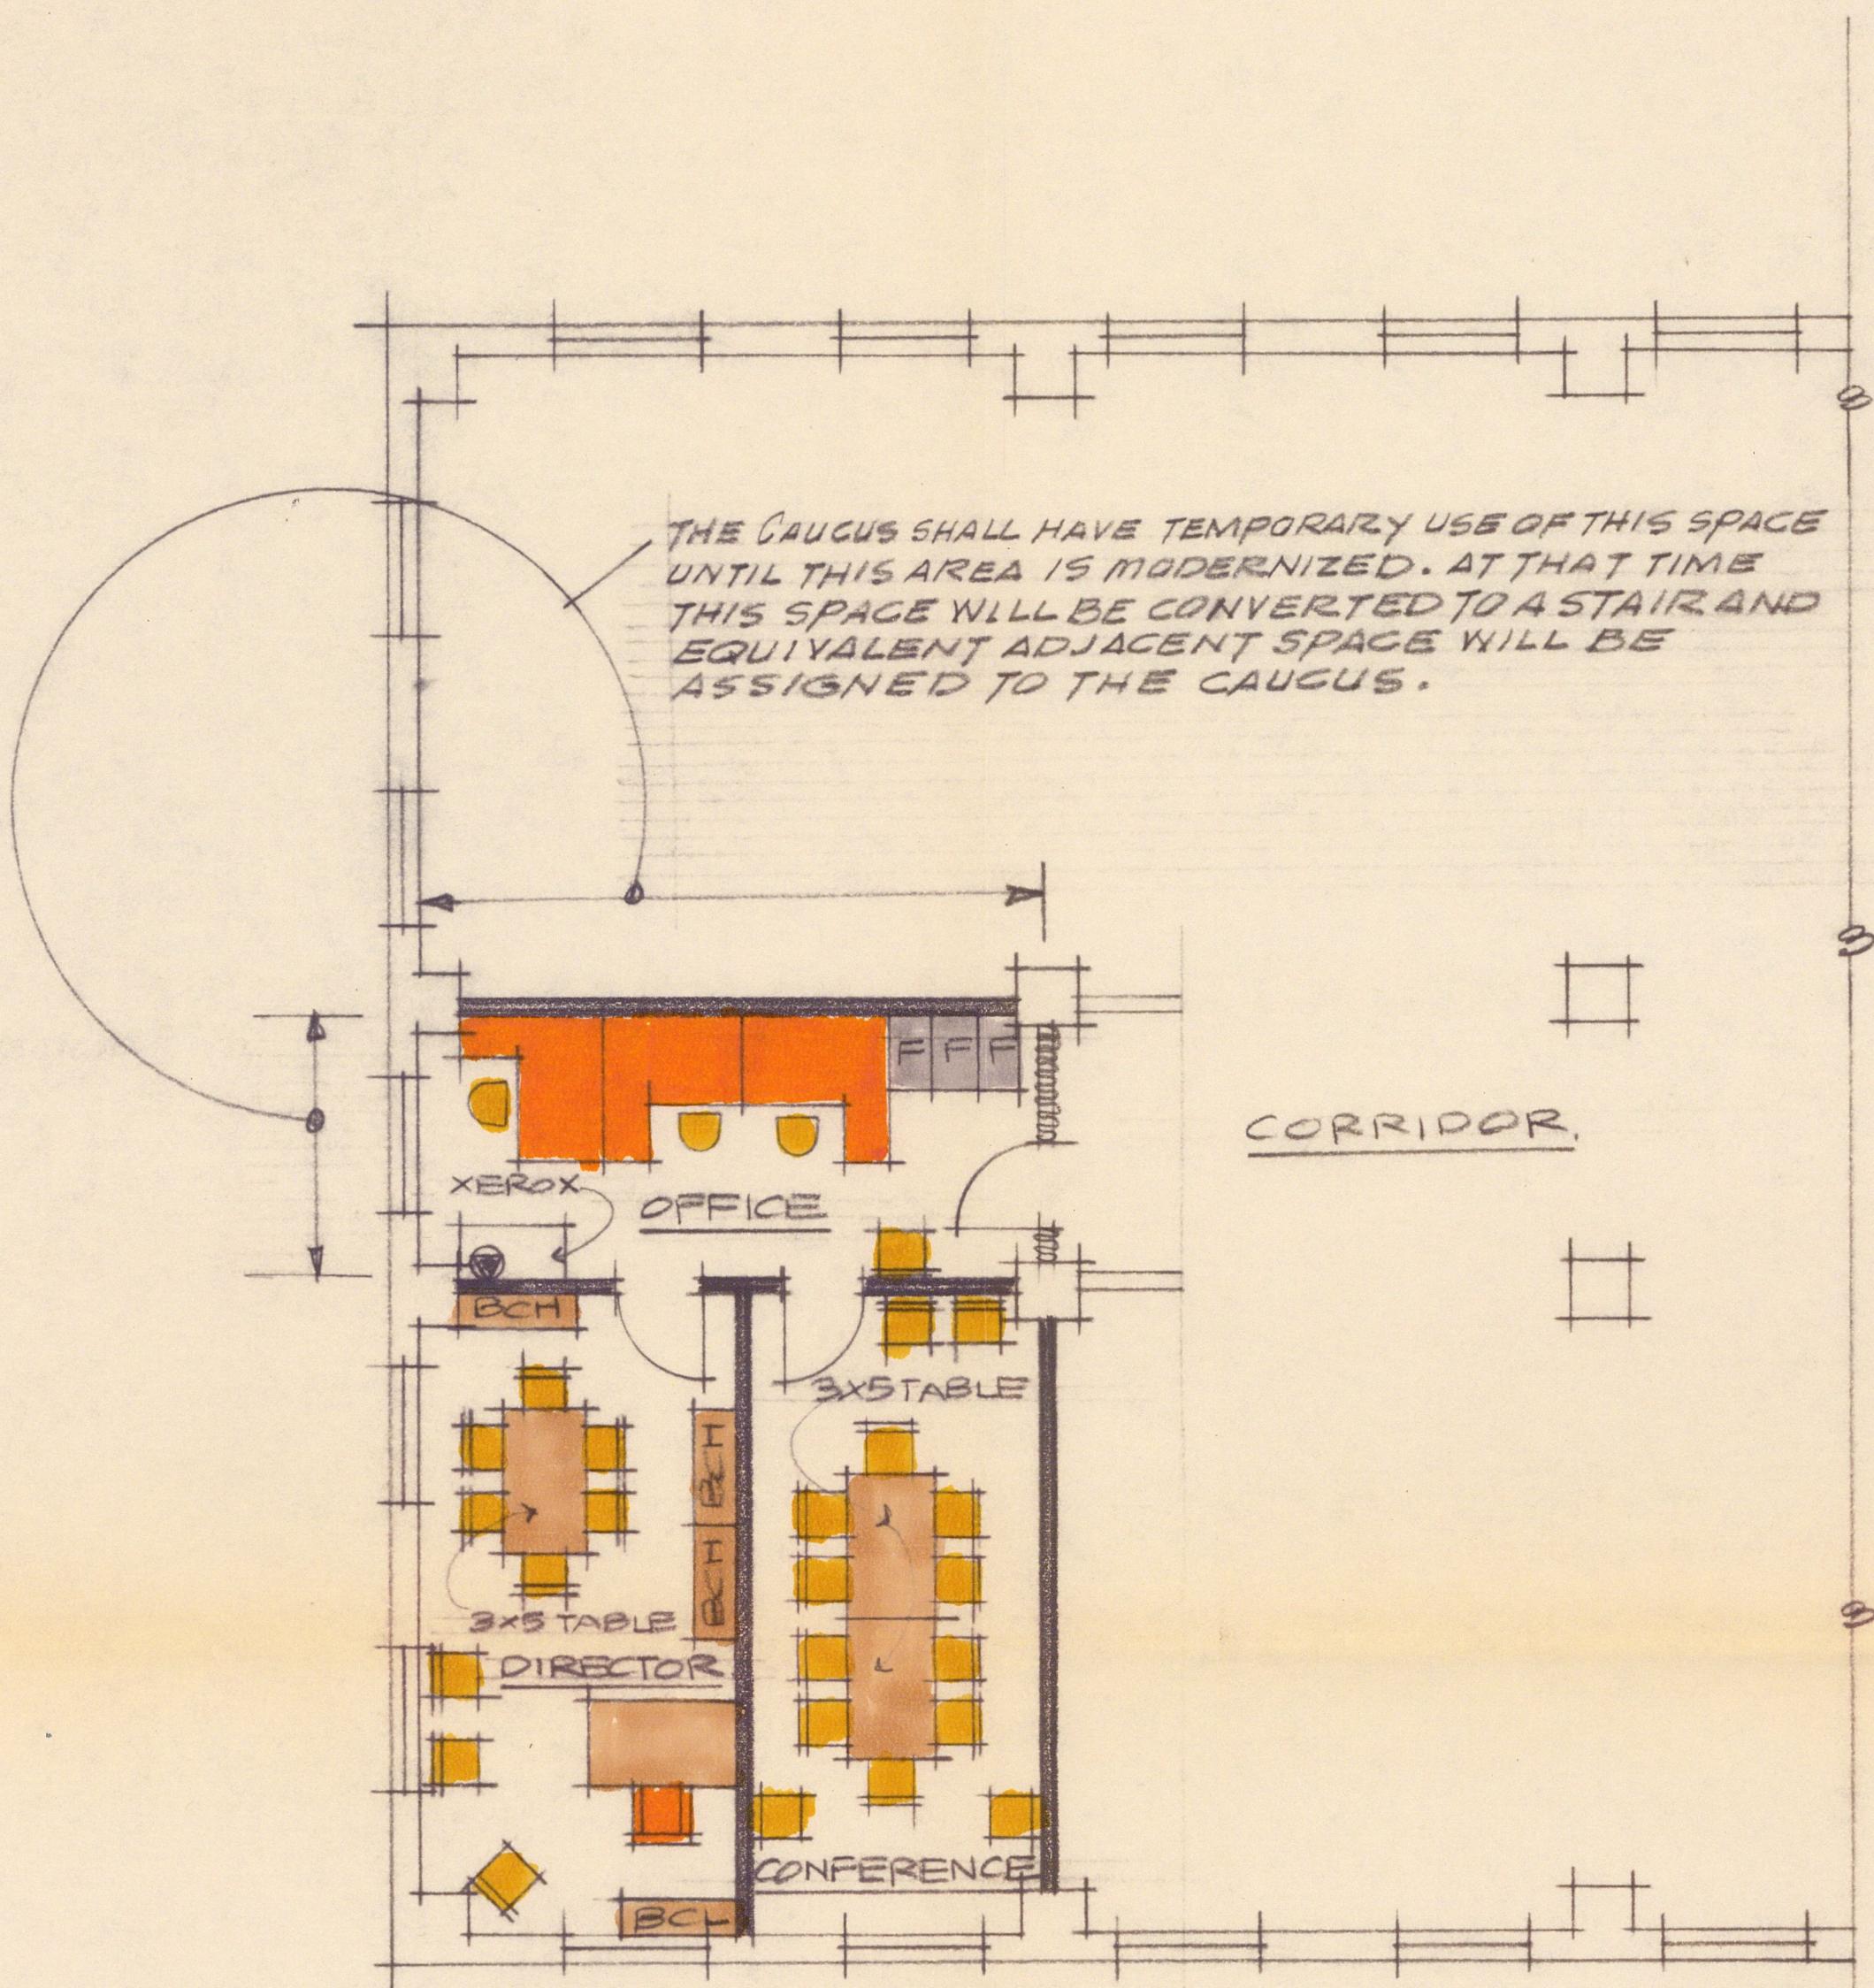


PARTIAL FIFTH FLOOR PLAN SCALE: 1/8"=1'-0"

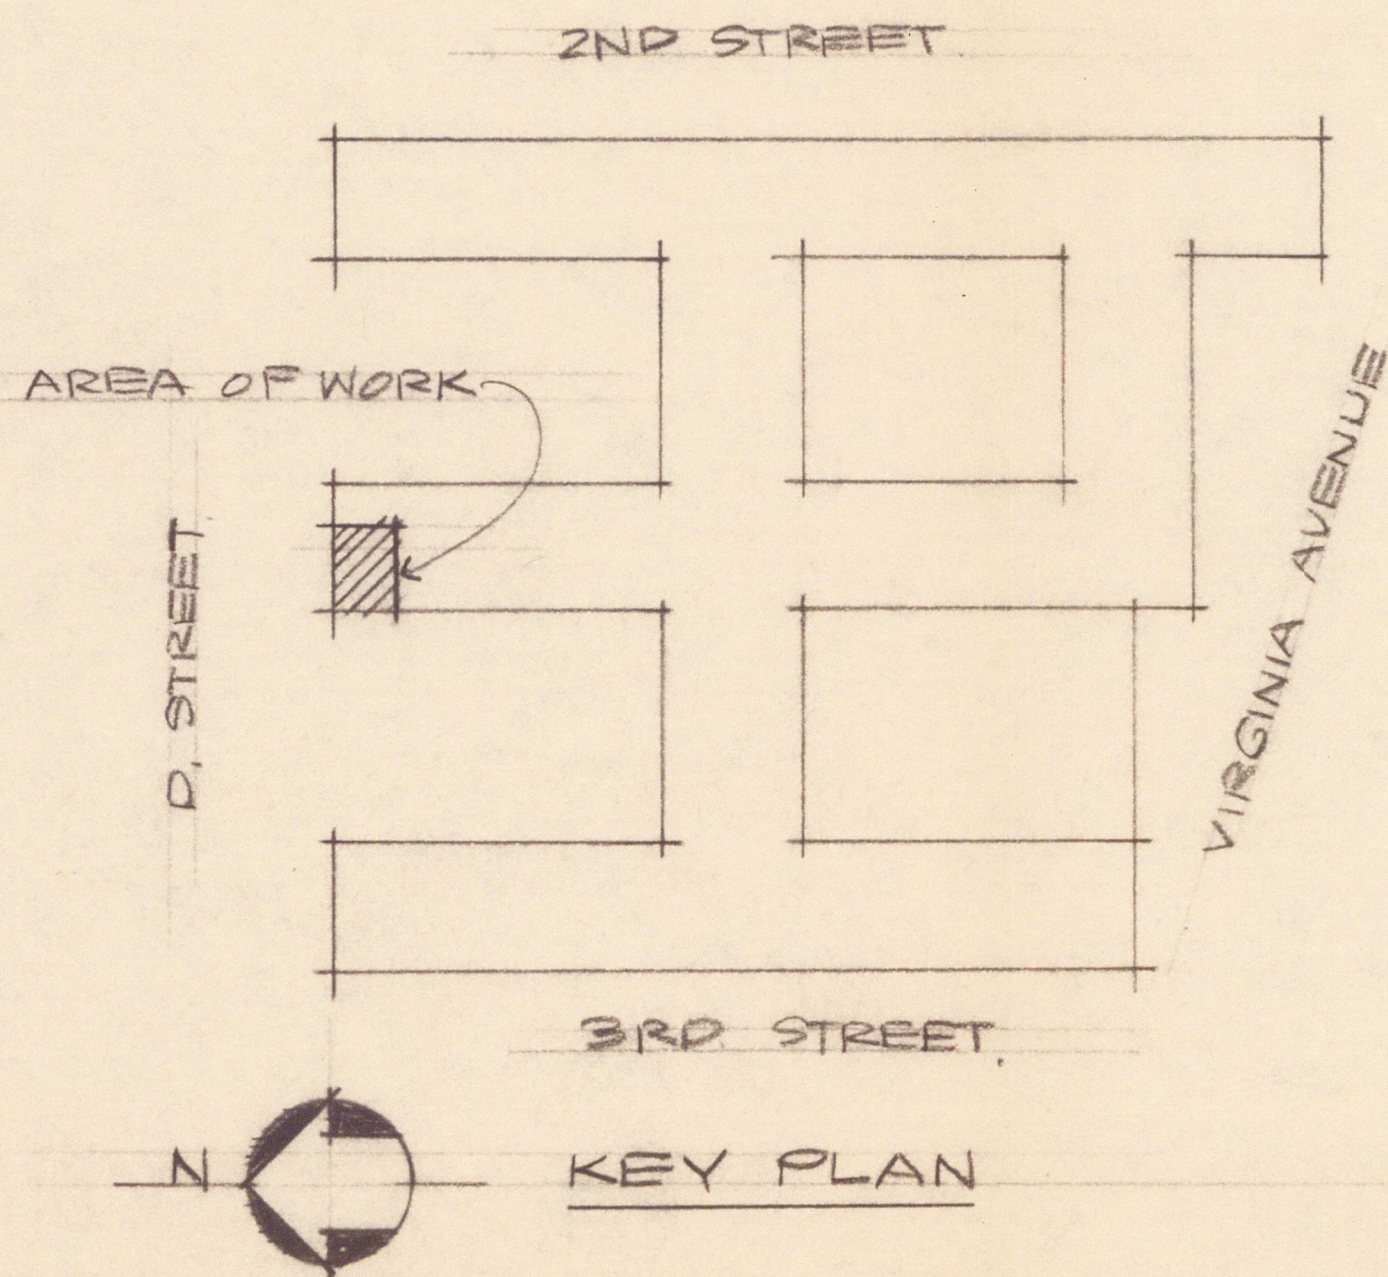

LEGEND OF FURNITURE

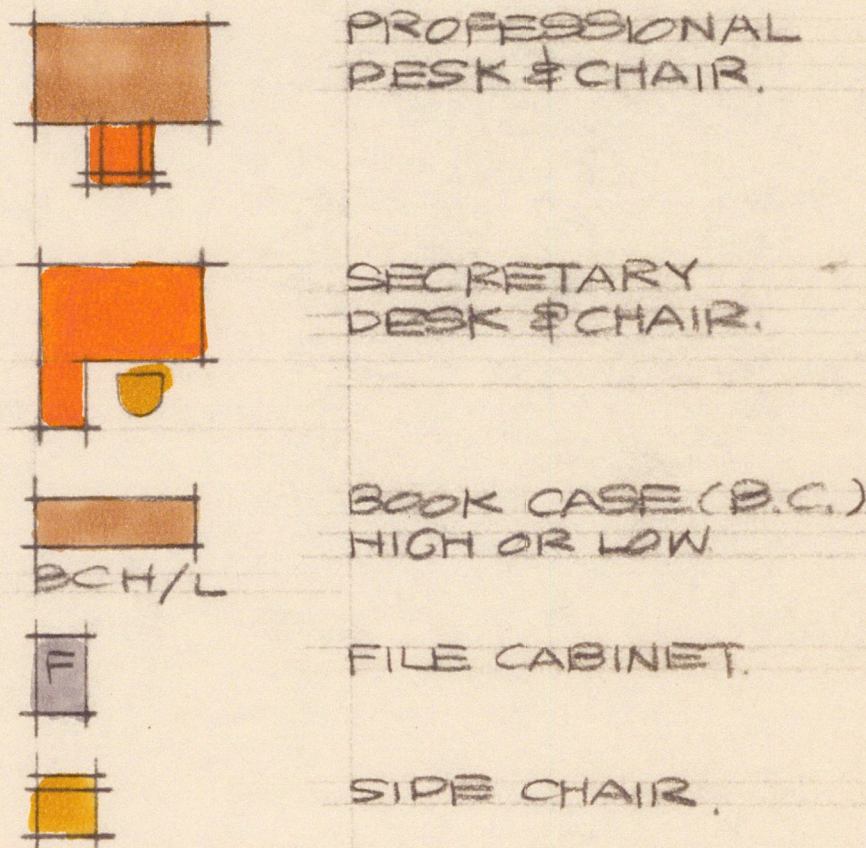


LEGEND

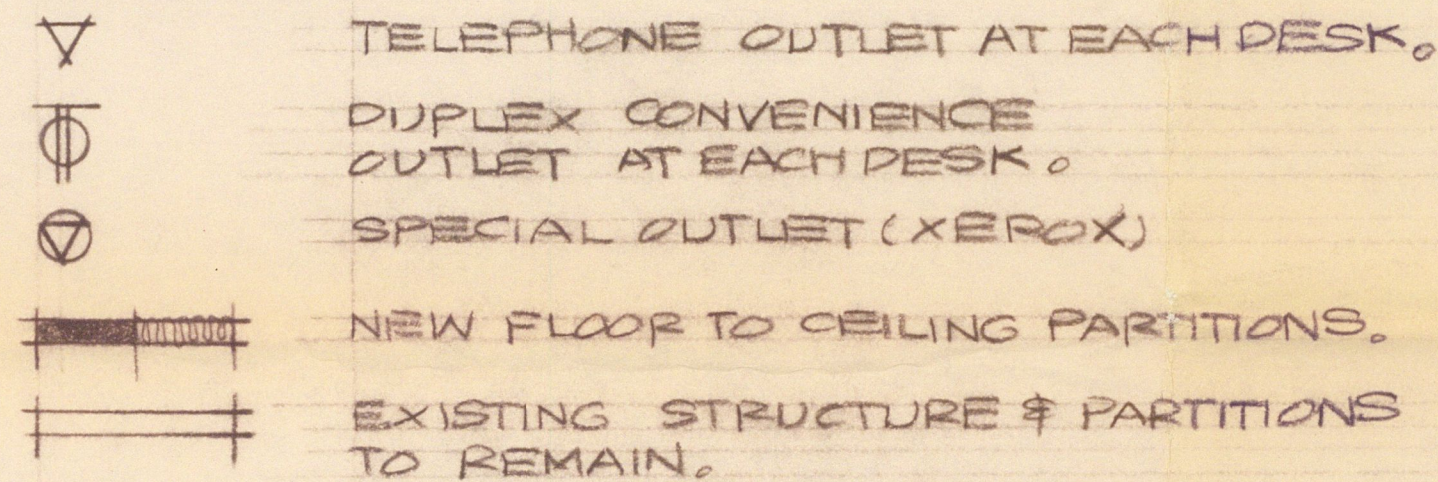

ALL FURNITURE & FURNISHINGS WILL BE PROVIDED BY THE CLERK OF THE HOUSE OF REPRESENTATIVES.

TELEPHONES WILL BE FURNISHED AND INSTALLED BY THE C & P TELEPHONE COMPANY. THE TENANT SHALL OBTAIN PRIOR APPROVAL FROM THE HOUSE ADMINISTRATION COMMITTEE.

APPROVED BY CONGRESSMAN EDWARD R. ROYBAL
DATED APRIL 12 1977.

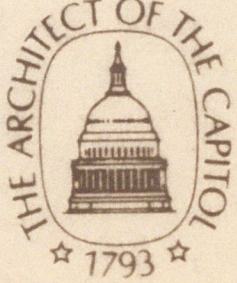RECOMMENDED FOR APPROVAL:		PROJECT TITLE		NO.		REVISIONS		DATE	
COORDINATING ENGINEER		HOUSE OFFICE BUILDING ANNEX #2 PRELIMINARY DRAWING							
ASSISTANT ARCHITECT OF THE CAPITOL				DRAWING TITLE		DRAWN BY		KEY PLAN	
APPROVED				PARTIAL FIFTH FLOOR PLAN		J.B.			
ARCHITECT OF THE CAPITOL				FURNITURE LAYOUT FOR THE CONGRESSIONAL HISPANIC CAUCUS		CHECKED M.E.C.			
				SCALE		DATE		DRAWING NO.	
				AS SHOWN		4/6/77			
				SHEET		1 OF 1			
		GEORGE M. WHITE FAIA ARCHITECT OF THE CAPITOL							