




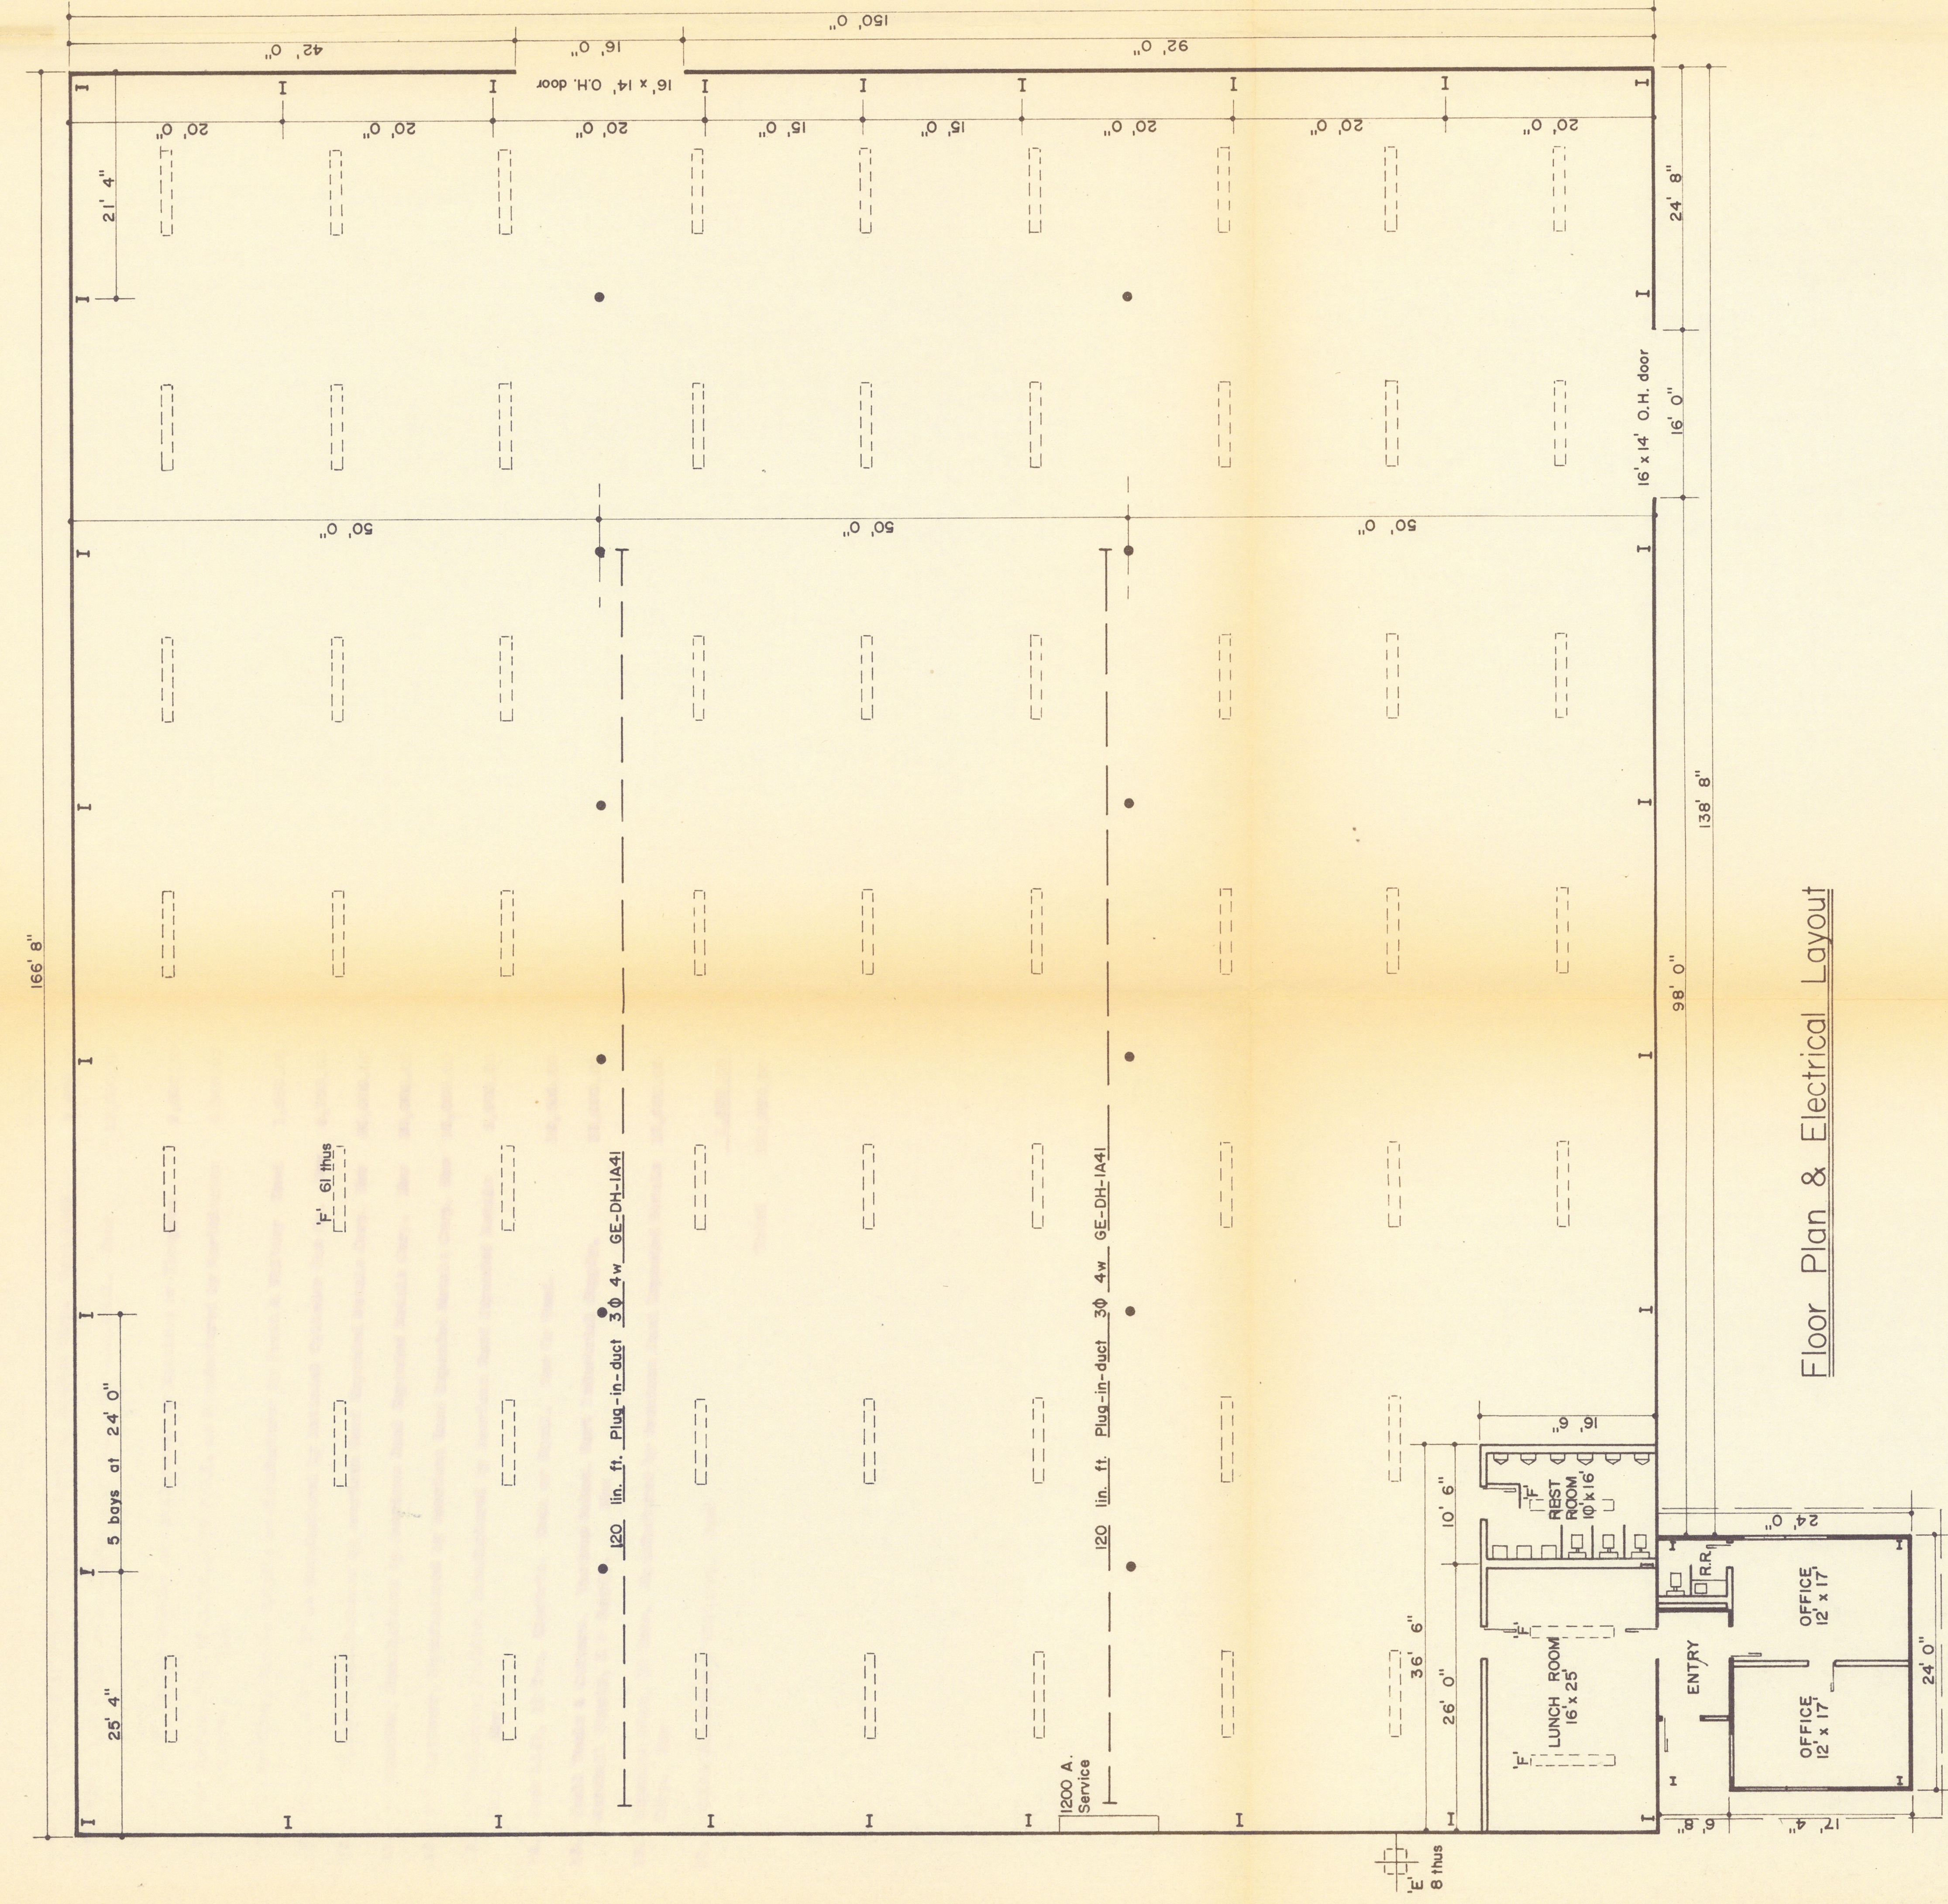


Floor Plan & Electrical Layout

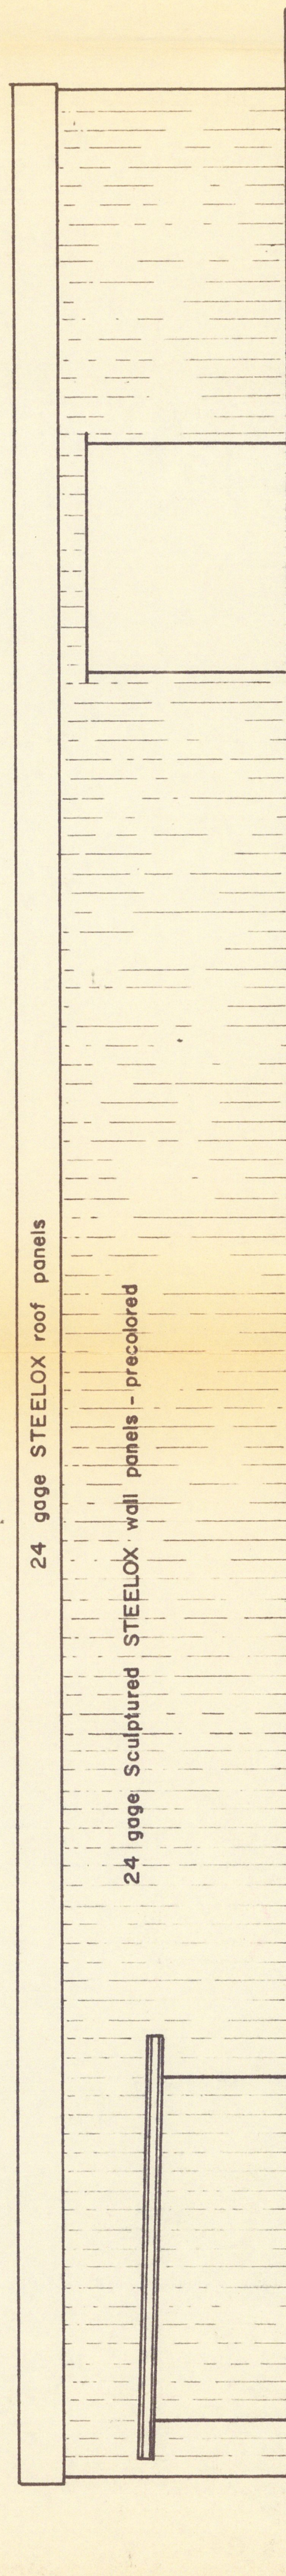

Side Elevation

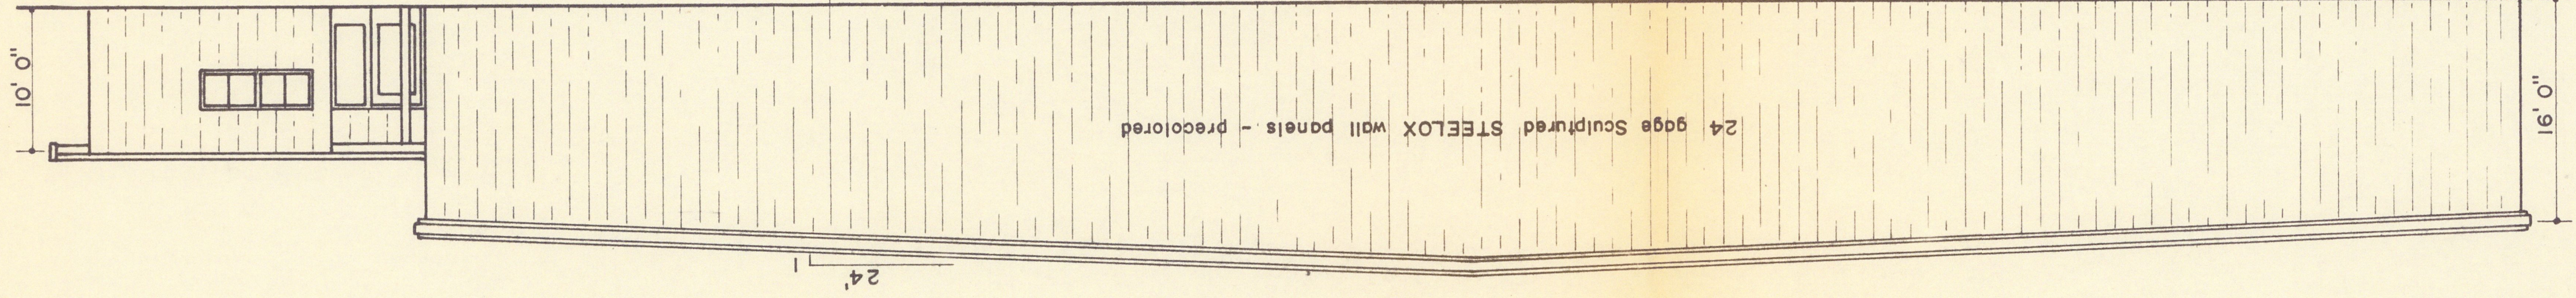

Front Elevation

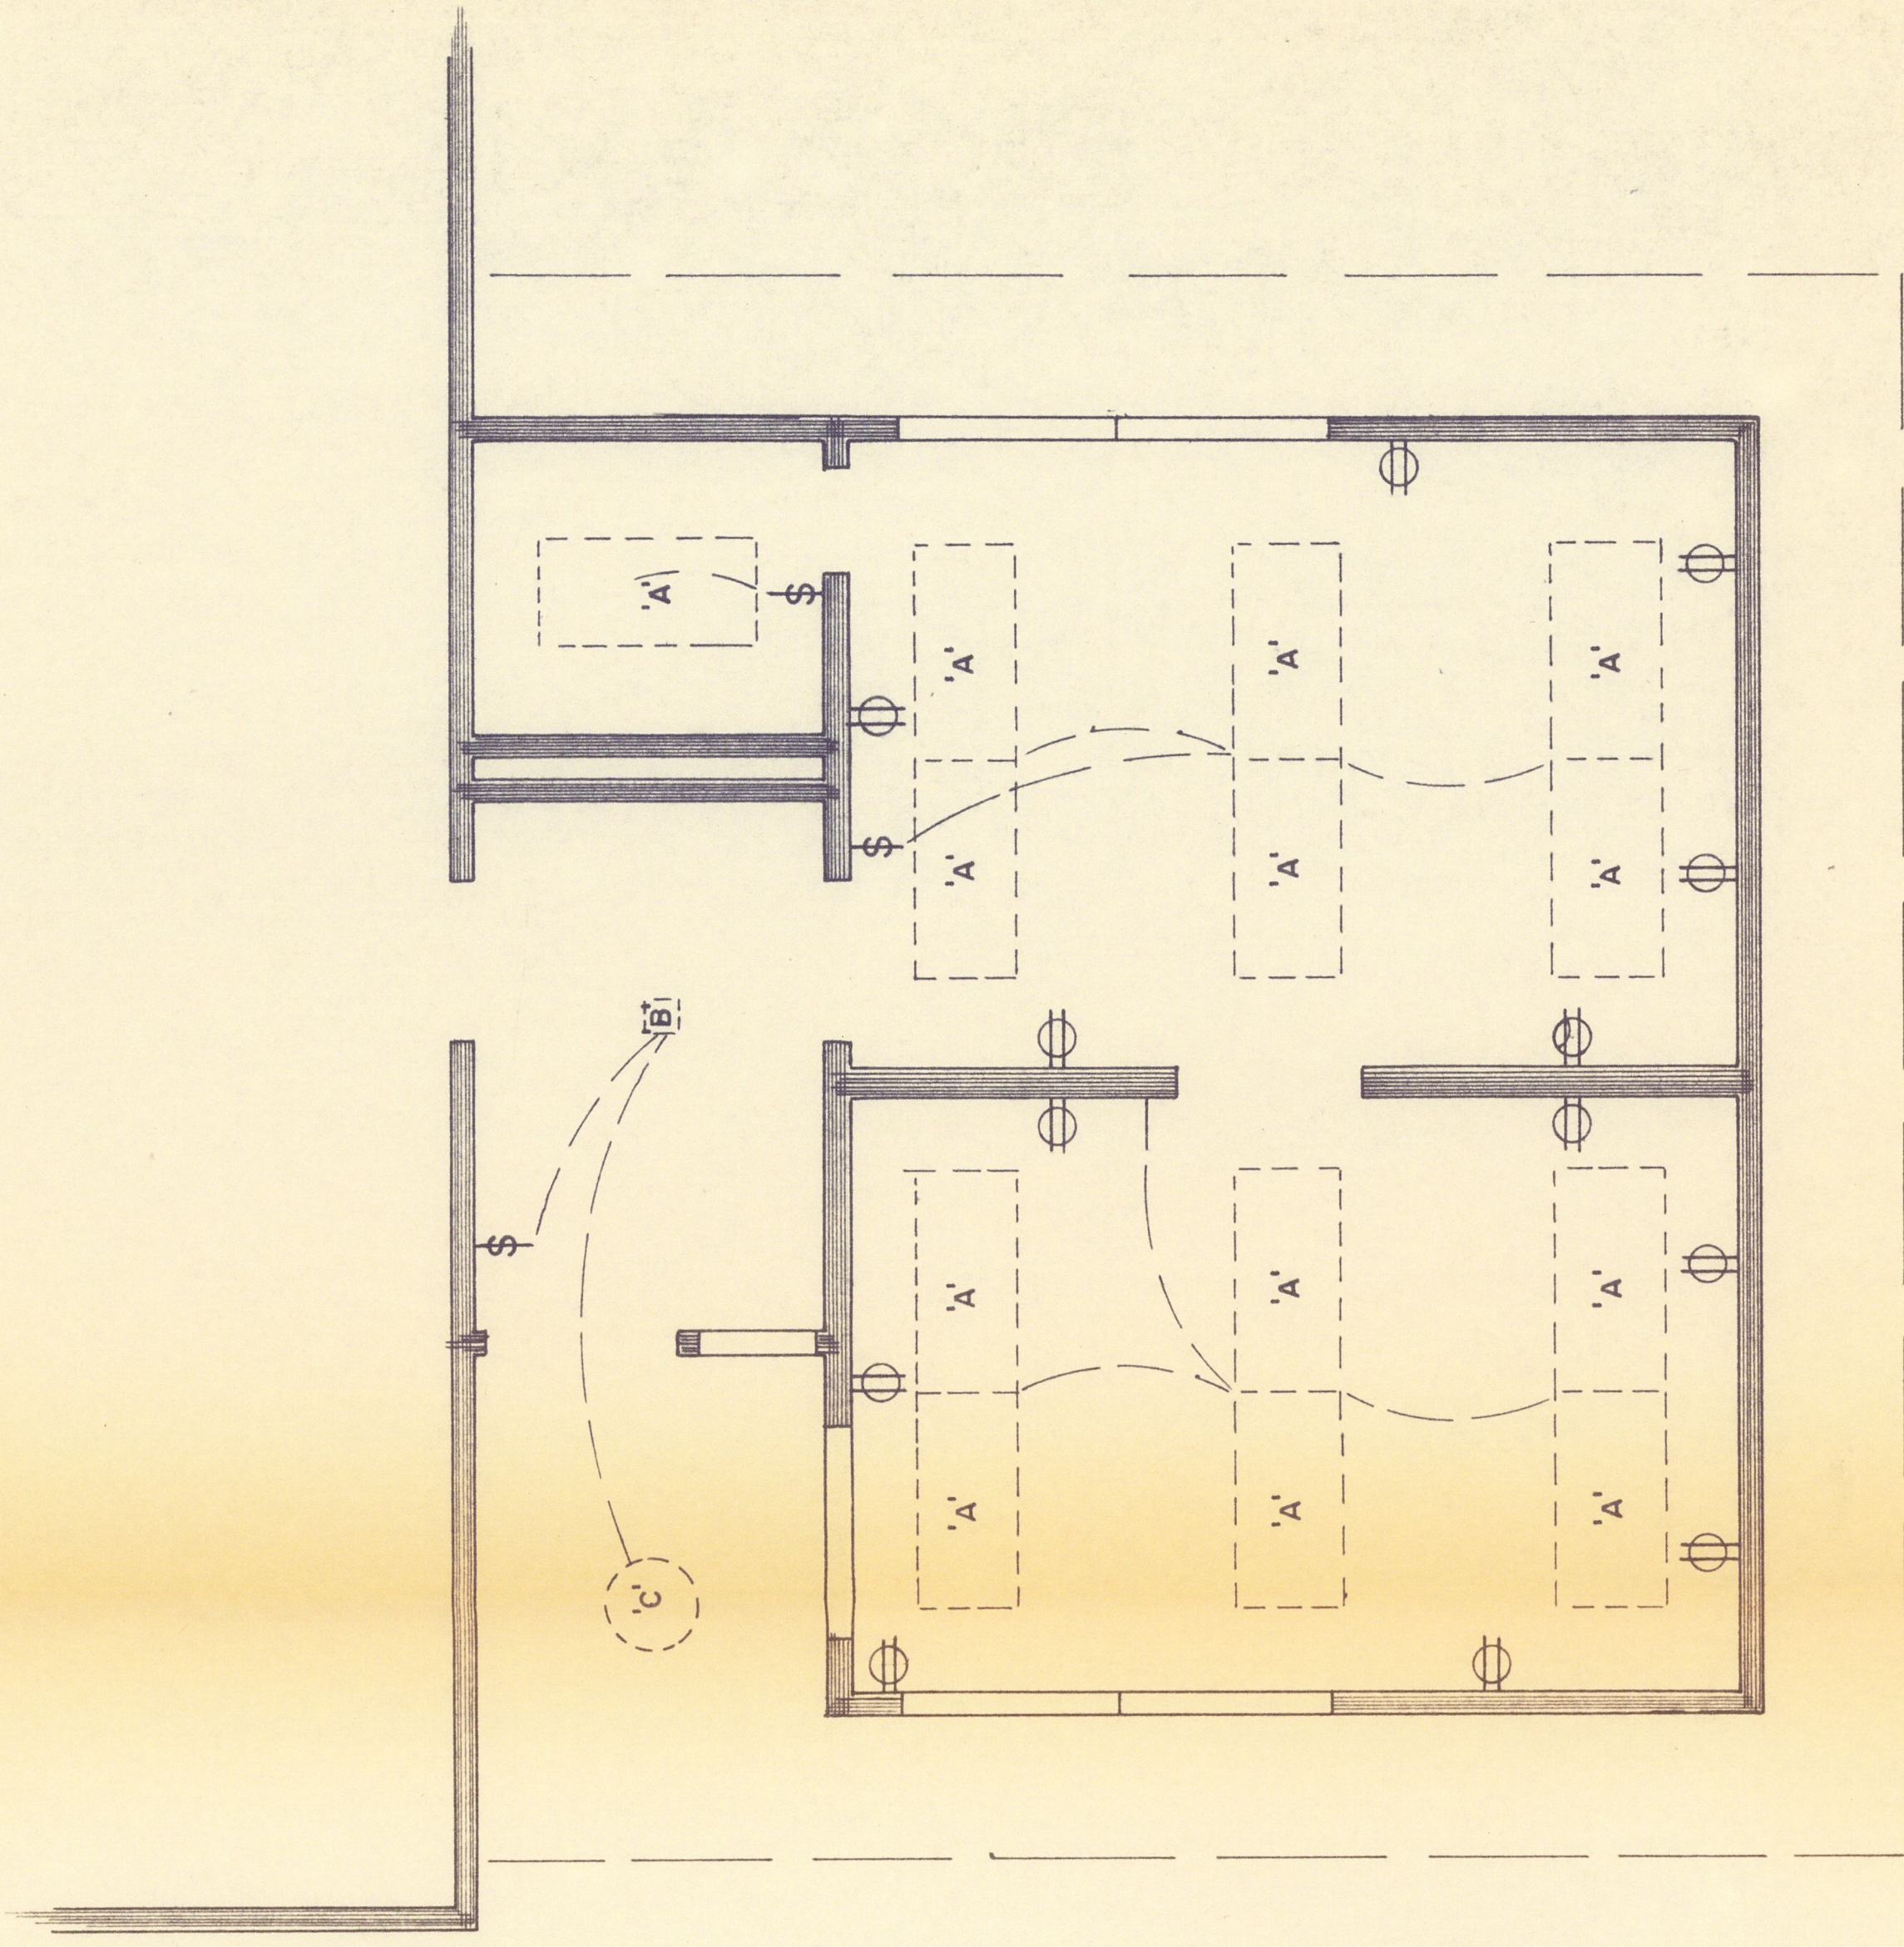

Office Electrical Layout

MAIN SERVICE SWITCH
1200 A 3 pole 4w "HD"
MDP 5 pole 4w 120/208 volt-1200 AMLO
2-100 A 3 pole
2-100 A 3 pole
1- 200 A 3 pole space
2-lighting panels - 30 circuits each

FIXTURES
A Columbia FRSF-TB-24-440-M37
B Solo 9002-9212W-100 watt
C Lighdier 101-1105-150 watt
E Miller 200 watt angle reflector
F Lithonia 2 light 96

Albert Maps # 173

PRODUCTION FACILITIES			
SCALE: 3/32" = 1" 0"		APPROVED BY:	DRAWN BY CJS
DATE: 2-20-67			REVISED
AMERICAN RAND EXPANDED METAL CORP.			
Plan by STOLDT BUILDERS, INC		DRAWING NUMBER 2-F20	